




 


# UNIT TYPE - 1A

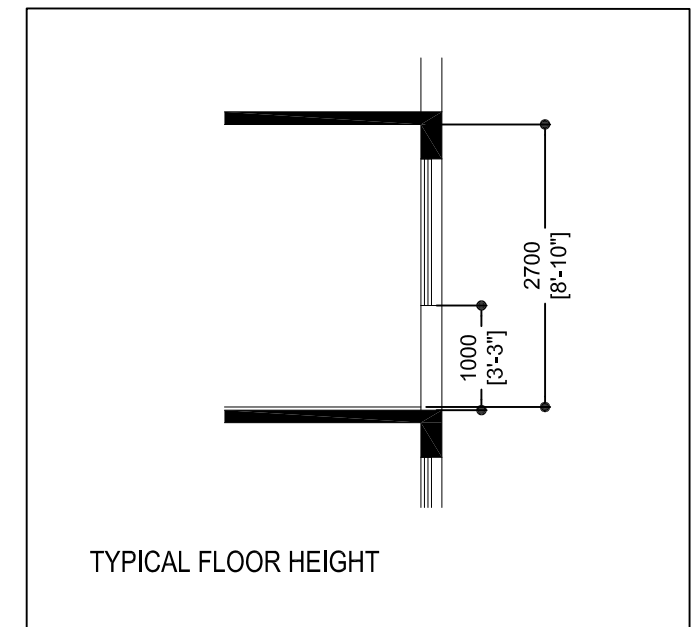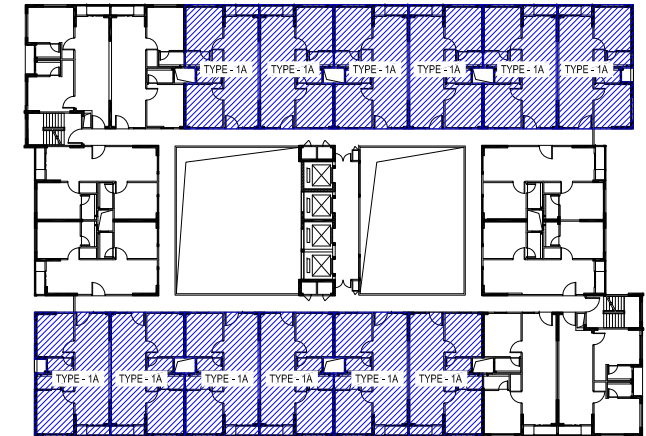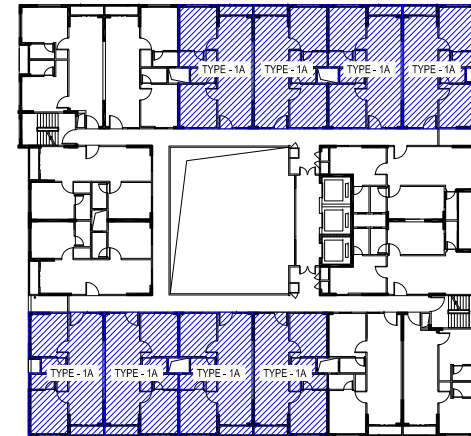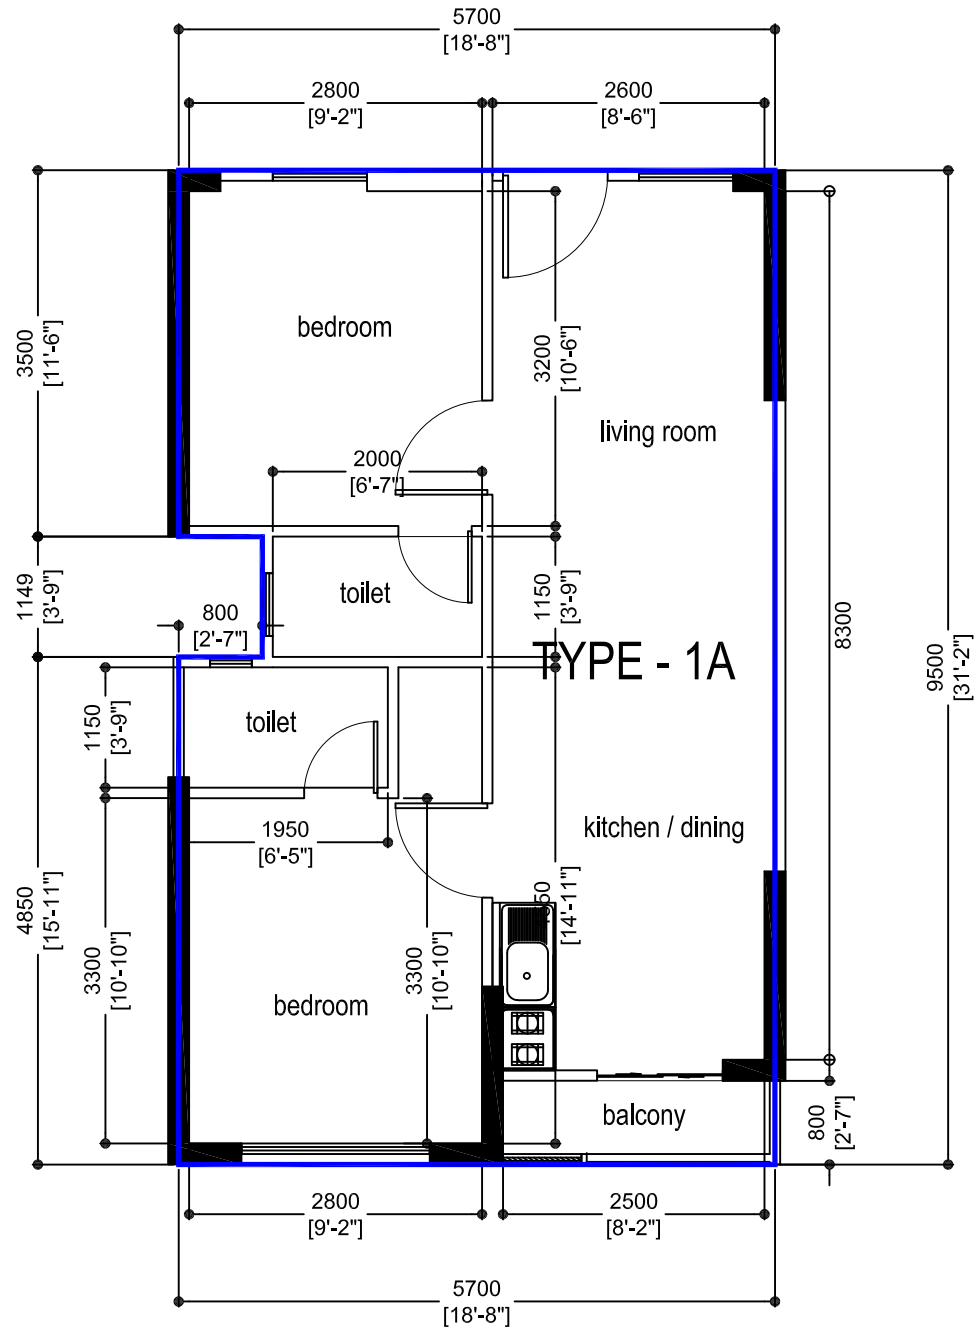


-  SHEAR WALLS
-  MASONRY WALLS

THE MEASUREMENTS MENTIONED ABOVE  
MIGHT BE SUBJECT TO SLIGHT CHANGES  
ONCE AN AS-BUILT HAS BEEN TAKEN


DETAIL DRAWING

UNIT TYPE - 1A : 53.23 m<sup>2</sup> (572.96 ft<sup>2</sup>)

SCALE: 1:100

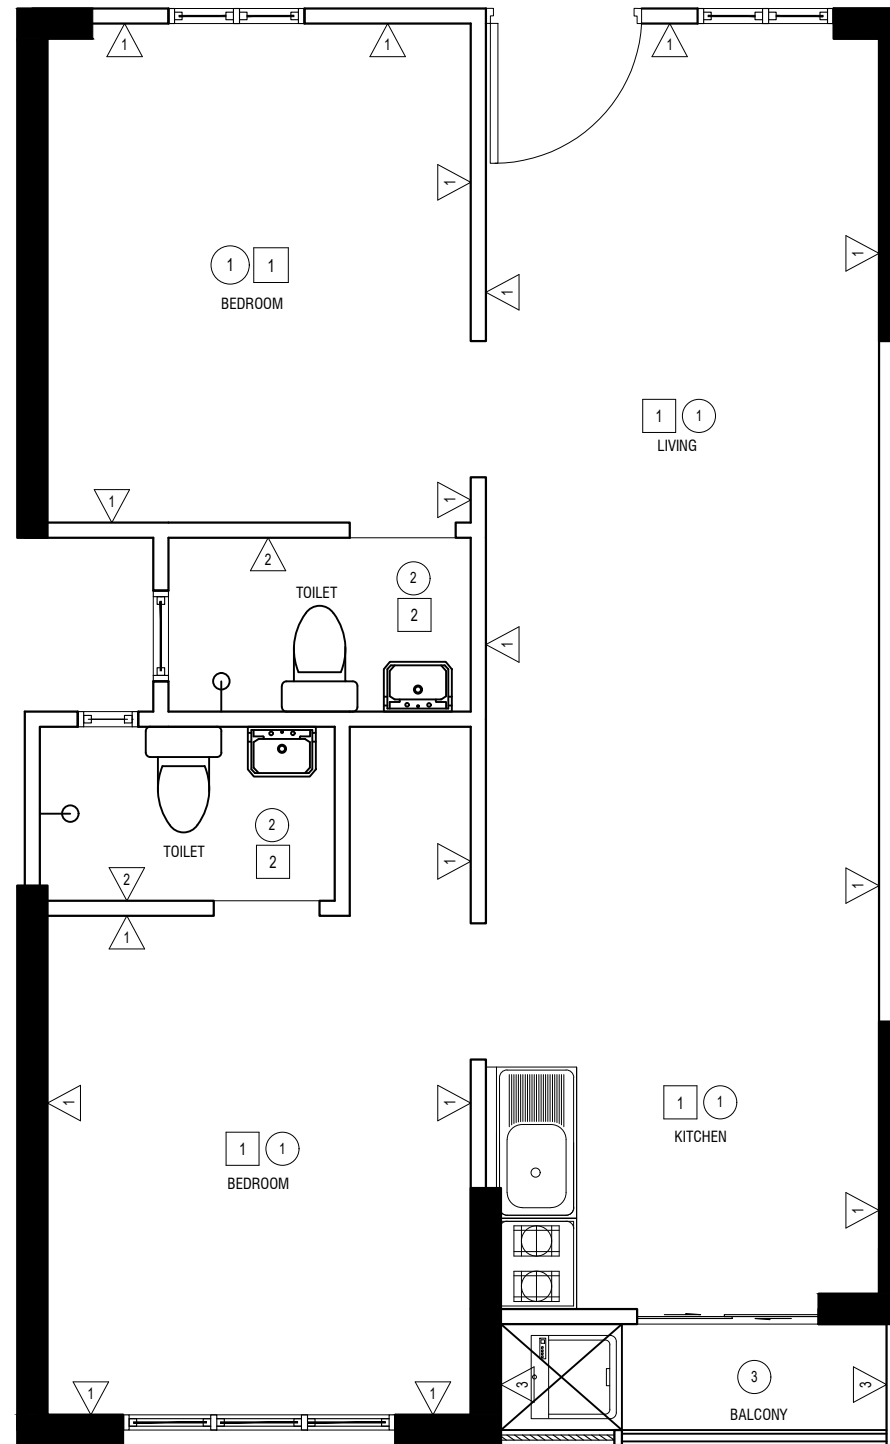

 **FINISHING SCHEDULE TYPE -1A**  
SCALE 1:50



1	FLOOR FINISH
1	CEMENT SCREED
2	TILES
1	CEILING FINISH
1	SLAB SOFFIT WITH WHITE PUTTY
2	GYPSUM BOARD CEILING
3	PAINT FINISH
W	WALL FINISH
1	WHITE PUTTY FINISH
2	WALL TILES UP TO 1200 MM
3	PAINT FINISH

DESIGNER:

Architectural	Structural
---------------	------------

DRAWN BY:

**AMEEN & NAZA**  
JUNE 2021

REVISION NAME	DATE

SCALE: SHEET NO:

CHECKED BY:

**MOHAMED SAIF** NAME  
Architectural Structural

Electrical & Mechanical Communication


APPROVED BY:

**HUSSAIN ZIYATH**  
19/04/2020


SHEET CONTENT:

----


PAGE NO.

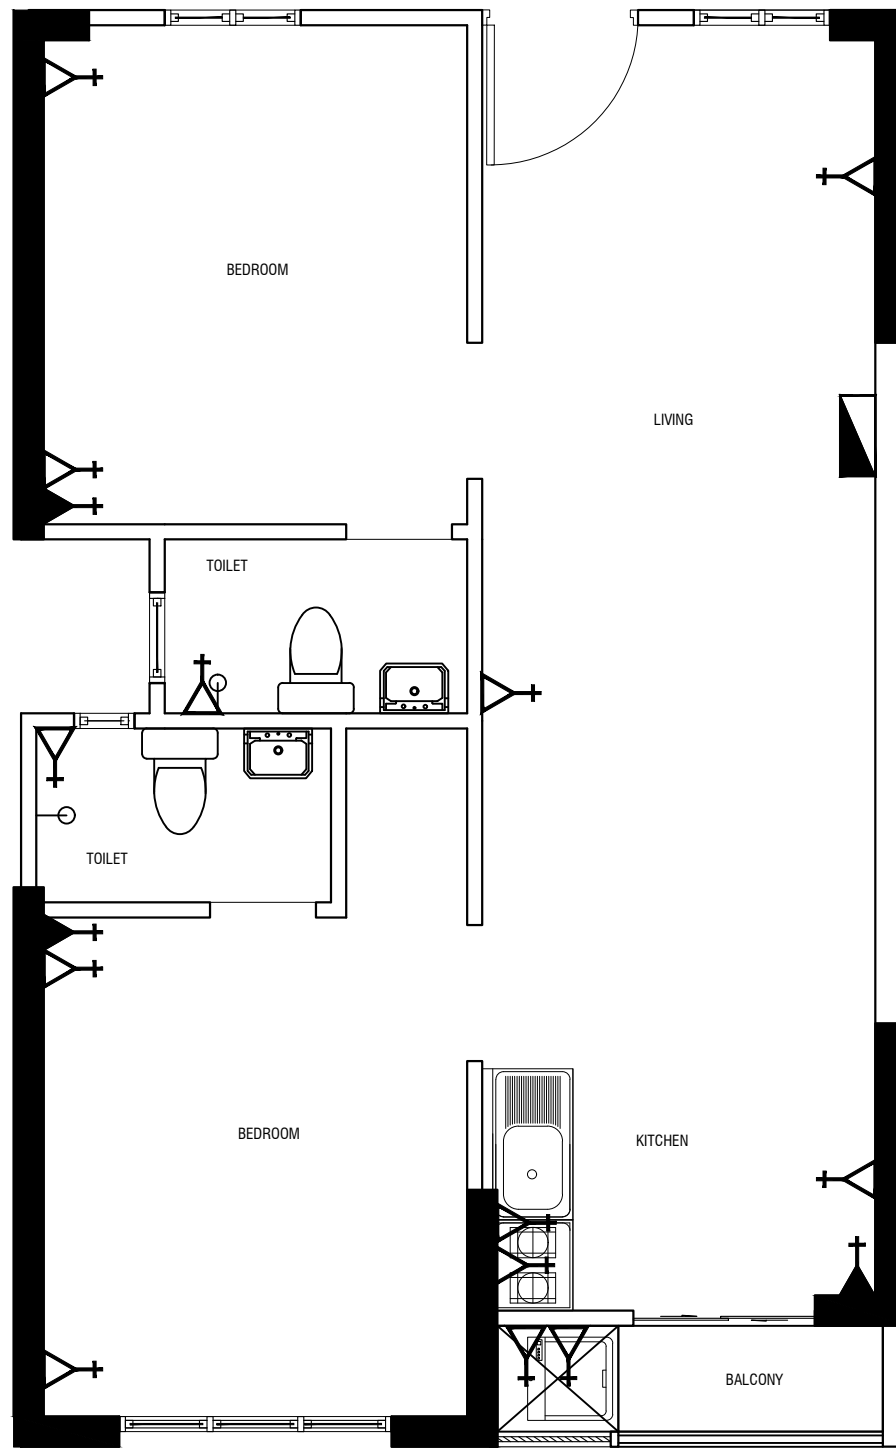

 **POWER LAYOUT (TYPE -1A)**  
SCALE 1:50




LEGEND	
SYMBOL	DESCRIPTION
	13 A SOCKET
	15 A SOCKET
	DISTRIBUTION BOX

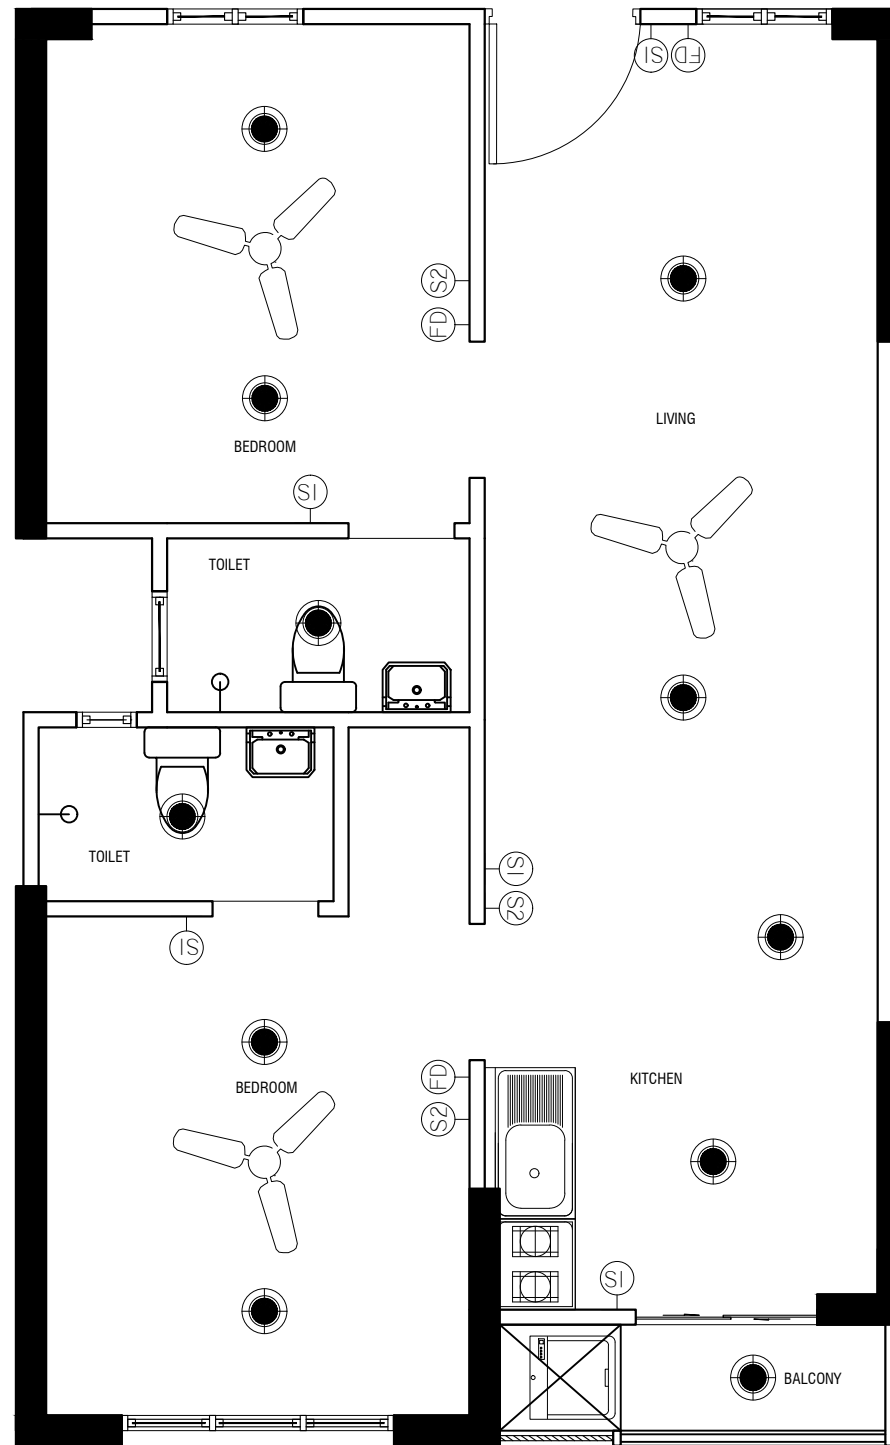

**PROVISIONS FOR LIGHTS AND FAN (TYPE -1A)**

 SCALE 1:50



LEGEND	DESCRIPTION
	PROVISION FOR LIGHT
	PROVISION FOR FAN
	SINGLE GANG SWITCH
	DOUBLE GANG SWITCH
	FAN CONTROL SWITCH

DESIGNER:

Architectural	Structural

DRAWN BY:

AMEEN & NAZA  
JUNE 2021

REVISION

NAME	DATE

SCALE:

SHEET NO:

CHECKED BY:

MOHAMED SAIF  
Architectural

NAME  
Structural

Electrical & Mechanical

Communication


APPROVED BY:

HUSSAIN ZIYATH  
19/04/2020


SHEET CONTENT:

----

PAGE NO.

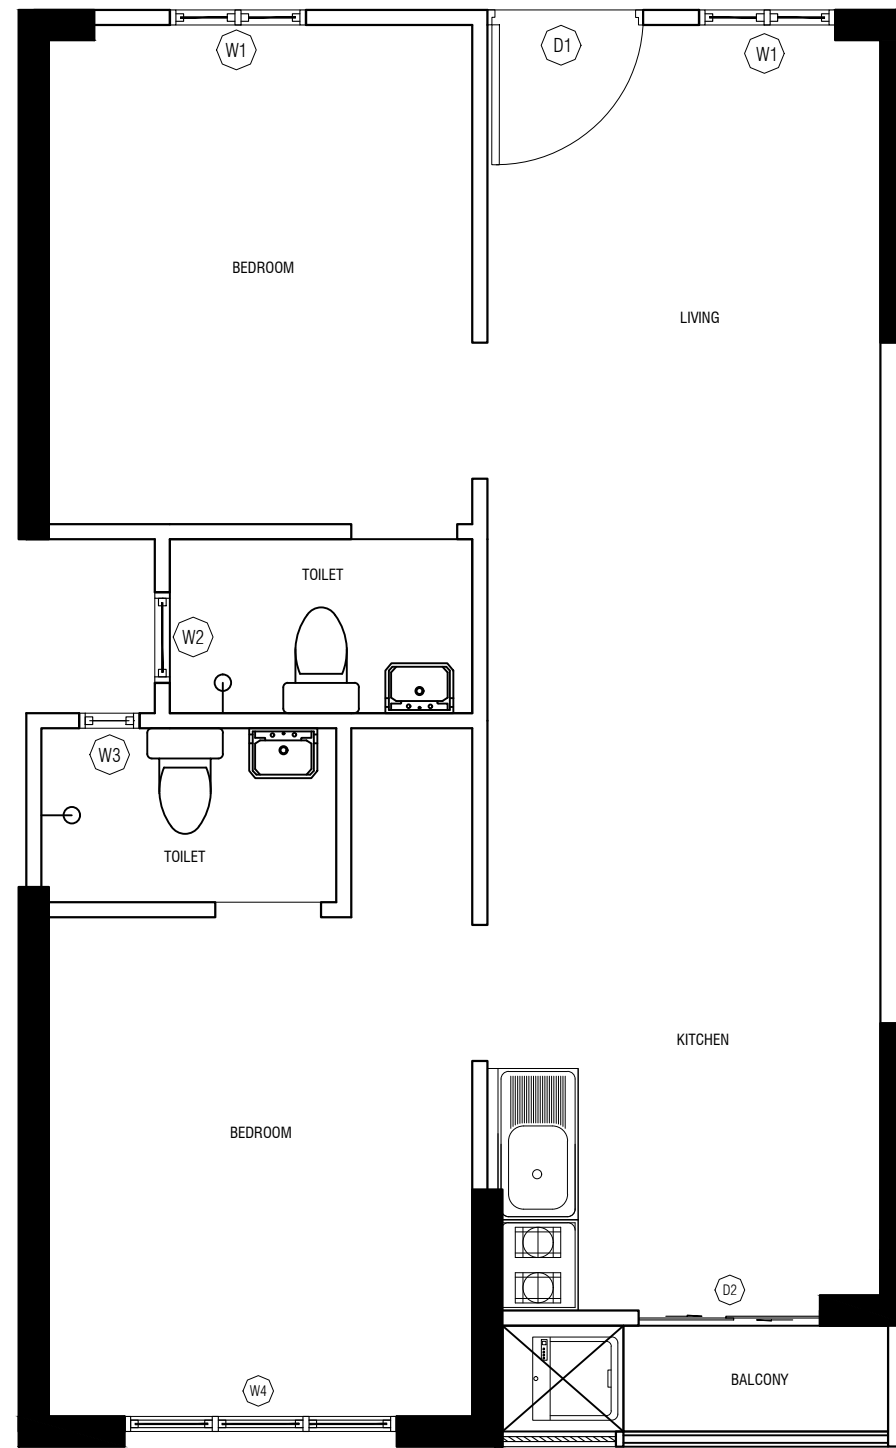

 **DOORS AND WINDOWS PLAN - (TYPE-1A)**  
SCALE 1:50



DESIGNER:

Architectural

DRAWN BY:

**AMEEN & NAZA**  
JUNE 2021

REVISION

NAME	DATE

SCALE:

SHEET NO:

Structural

CHECKED BY:

**MOHAMED SAIF**  
Architectural

**NAME**  
Structural

Electrical & Mechanical

Communication

APPROVED BY:

**HUSSAIN ZIYATH**  
19/04/2020

SHEET CONTENT:

----

\_\_\_\_\_


\_\_\_\_\_

\_\_\_\_\_

\_\_\_\_\_


PAGE NO.

**04**

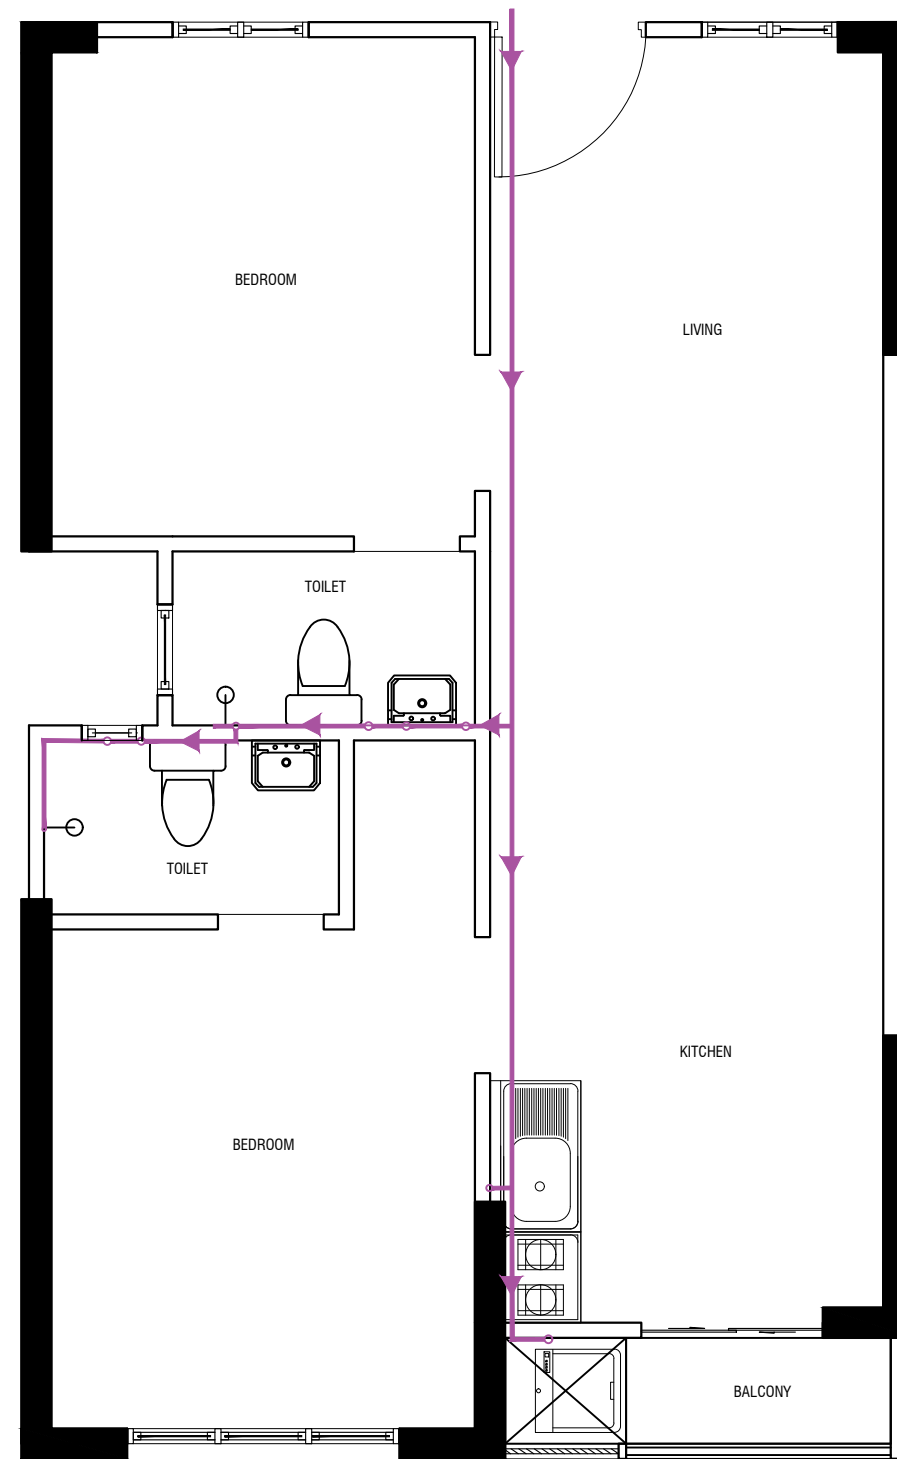

**FRESH WATER SUPPLY - (TYPE-1A)**

 SCALE 1:50



DESIGNER:	
Architectural	Structural

DRAWN BY:	
AMEEN & NAZA	
JUNE 2021	
REVISION	
NAME	DATE
SCALE:	SHEET NO:

CHECKED BY:	
MOHAMED SAIF	NAME
Architectural	Structural
Electrical & Mechanical	Communication


APPROVED BY:
HUSSAIN ZIYATH
19/04/2020

SHEET CONTENT:
----

PLAN						
ELEVATION						
Finished Floor Level						
DOOR / WINDOW SYMBOL (No.)	D1	D2	W1	W2	W3	W4
TYPE	WOODEN DOOR	ALUMINIUM SLIDING DOOR	ALUMINIUM WINDOW	ALUMINIUM WINDOW	ALUMINIUM WINDOW	ALUMINIUM WINDOW

## DOORS AND WINDOWS SCHEDULE

 SCALE 1:50



DESIGNER:

Architectural	Structural

DRAWN BY:

**AMEEN & NAZA**  
JUNE 2021

REVISION

NAME	DATE

SCALE:

SHEET NO:

CHECKED BY:

**MOHAMED SAIF**

Architectural

**NAME**

Structural

Electrical & Mechanical

Communication

APPROVED BY:

**HUSSAIN ZIYATH**

19/04/2020

SHEET CONTENT:

----

PAGE NO.

06

PLAN			
ELEVATION			
DOOR / WINDOW SYMBOL (No.)	W5	W6	D6
TYPE	ALUMINIUM WINDOW	ALUMINIUM WINDOW	ALUMINIUM AND GLASS

### DOORS AND WINDOWS SCHEDULE

SCALE 1:50

