





UNIT TYPE - 1B

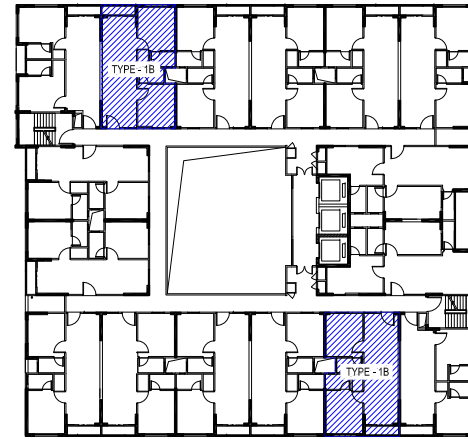

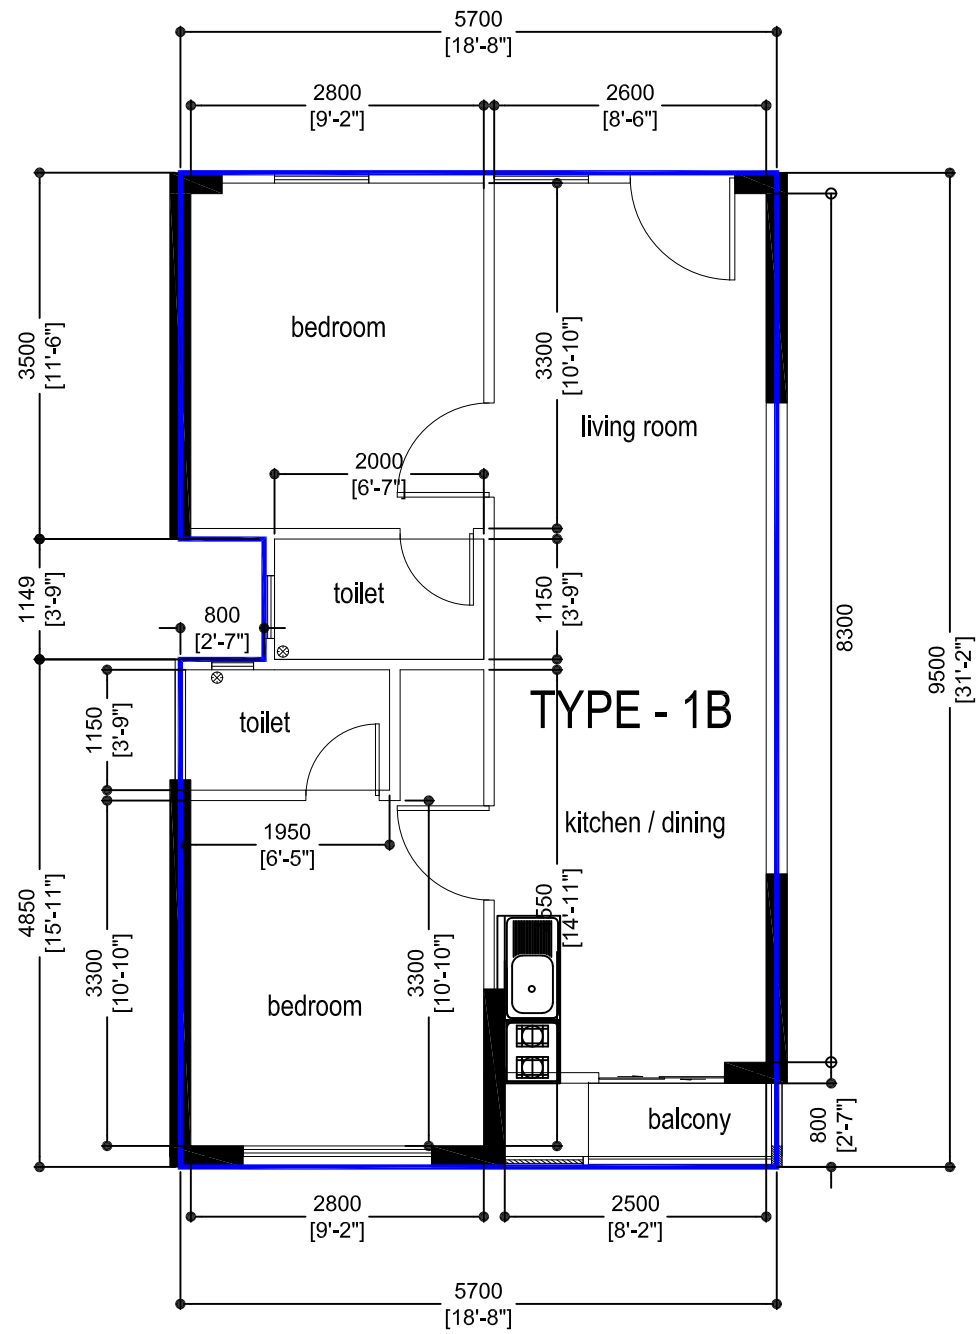

16 UNITS BUILDING

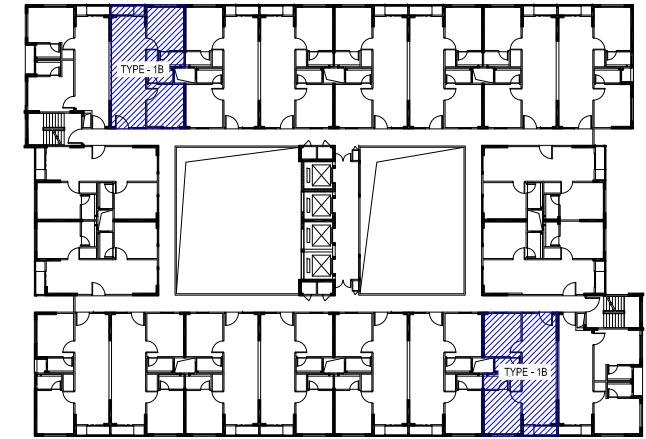

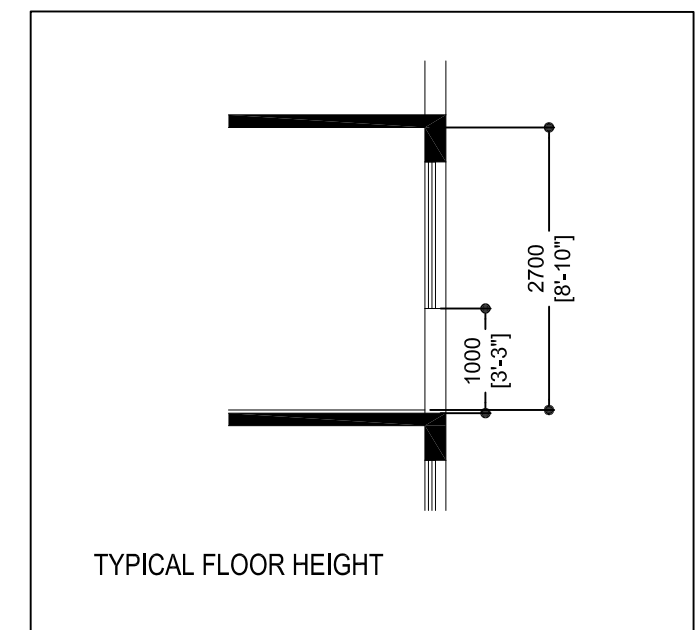20 UNITS BUILDING




-  SHEAR WALLS
-  MASONRY WALLS

THE MEASUREMENTS MENTIONED ABOVE
MIGHT BE SUBJECT TO SLIGHT CHANGES
ONCE AN AS-BUILT HAS BEEN TAKEN


DETAIL DRAWING

UNIT TYPE - 1B : 53.23 m² (572.96 ft²)

SCALE: 1:100

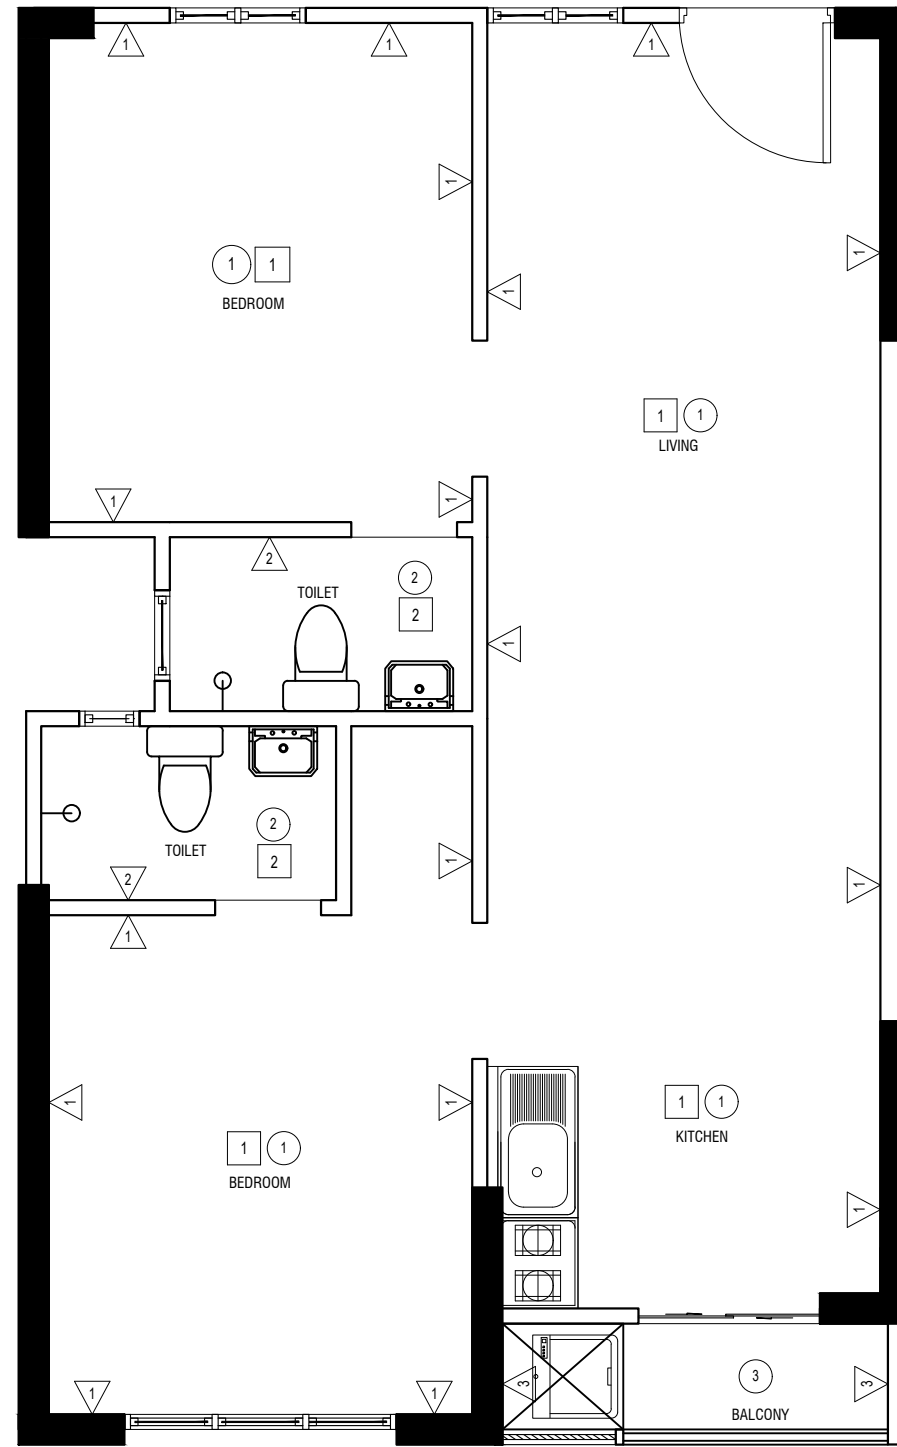


FINISHING SCHEDULE TYPE -1B
SCALE 1:50

 

1	FLOOR FINISH
1	CEMENT SCREED
2	TILES


1	CEILING FINISH
1	SLAB SOFFIT WITH WHITE PUTTY
2	GYPSUM BOARD CEILING
3	PAINT FINISH

W	WALL FINISH
1	WHITE PUTTY FINISH
2	WALL TILES UP TO 1200 MM
3	PAINT FINISH

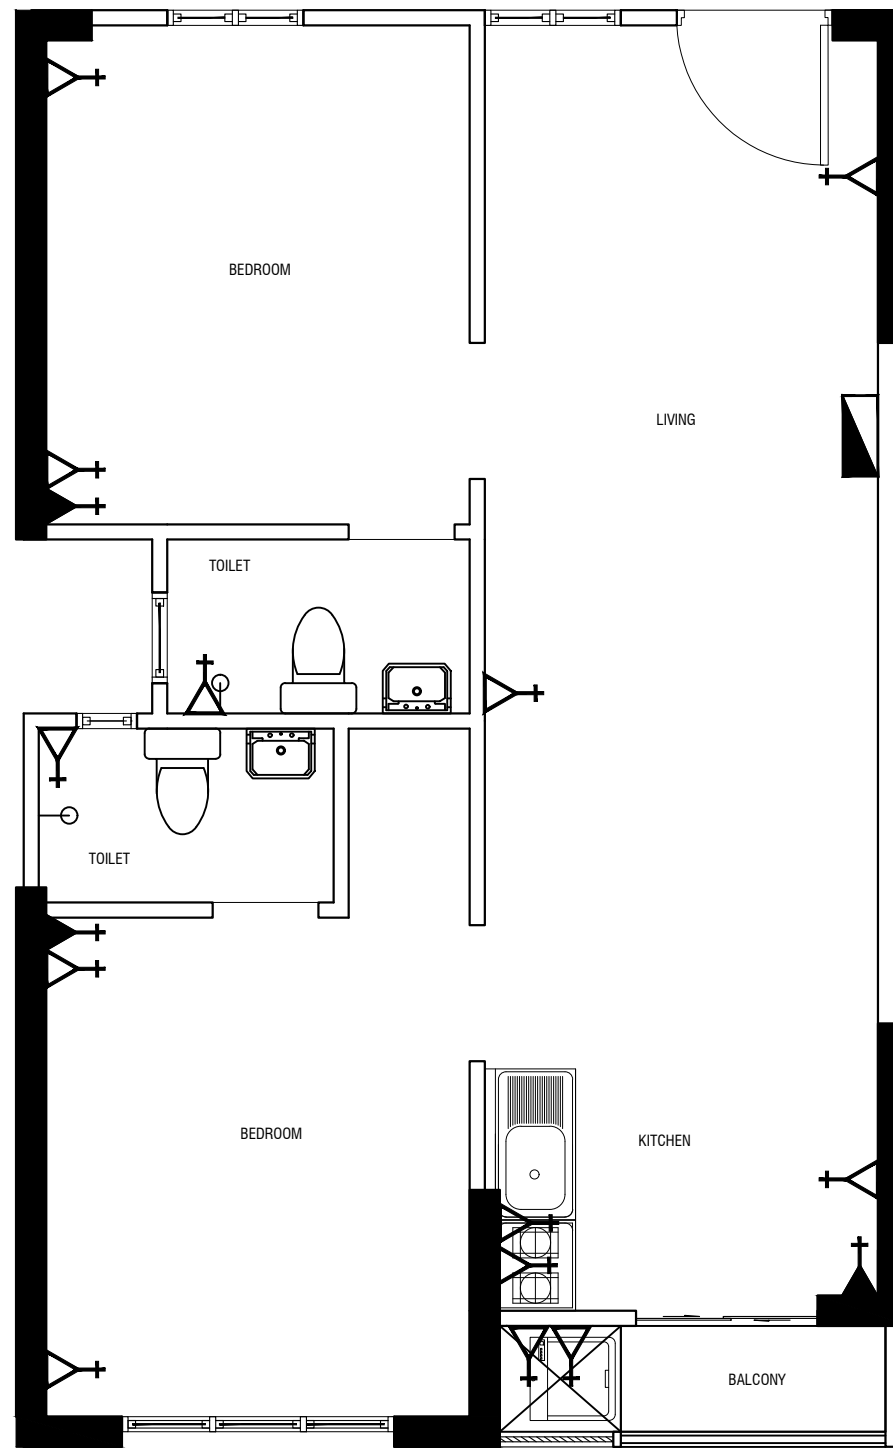

POWER LAYOUT (TYPE -1B)

 SCALE 1:50



LEGEND	DESCRIPTION
	13 A SOCKET
	15 A SOCKET
	DISTRIBUTION BOX


DESIGNER:	
Architectural	Structural

DRAWN BY:	
AMEEN & NAZA	
JUNE 2021	
REVISION	
NAME	DATE
SCALE:	
SHEET NO:	

CHECKED BY:	
MOHAMED SAIF	NAME
Architectural	Structural
Electrical & Mechanical	Communication


APPROVED BY:
HUSSAIN ZIYATH
19/04/2020

SHEET CONTENT:
9

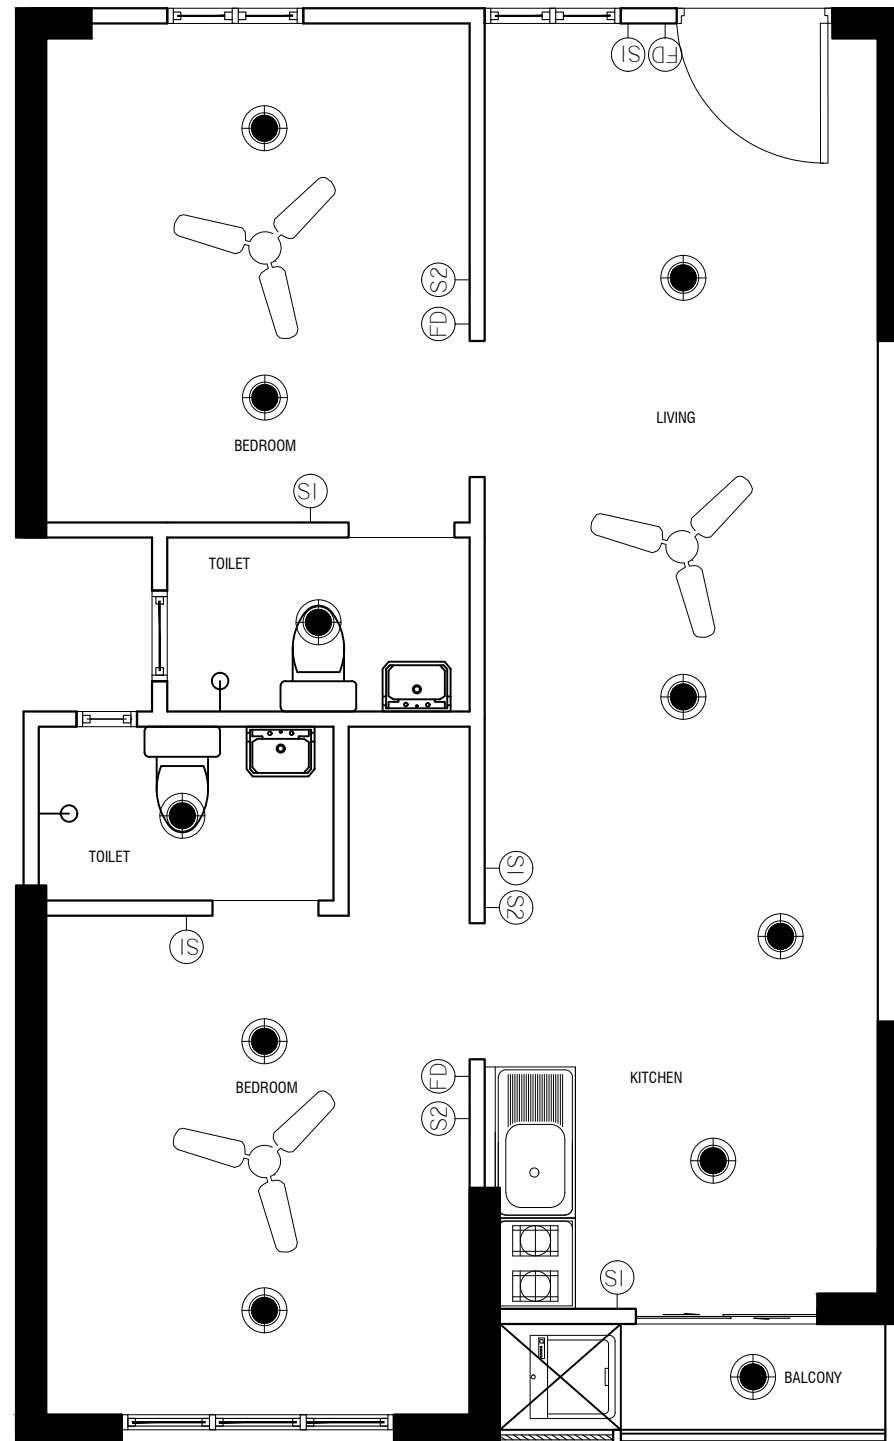

PROVISIONS FOR LIGHTS AND FAN (TYPE -1B)

 SCALE 1:50



LEGEND	DESCRIPTION
	PROVISION FOR LIGHT
	PROVISION FOR FAN
	SINGLE GANG SWITCH
	DOUBLE GANG SWITCH
	FAN CONTROL SWITCH

DESIGNER:

Architectural	Structural

DRAWN BY:

AMEEN & NAZA
JUNE 2021

REVISION	DATE
NAME	DATE

SCALE: SHEET NO:

CHECKED BY:

MOHAMED SAIF	NAME
Architectural	Structural


Electrical & Mechanical Communication

APPROVED BY:

HUSSAIN ZIYATH
19/04/2020


SHEET CONTENT:

PAGE NO.

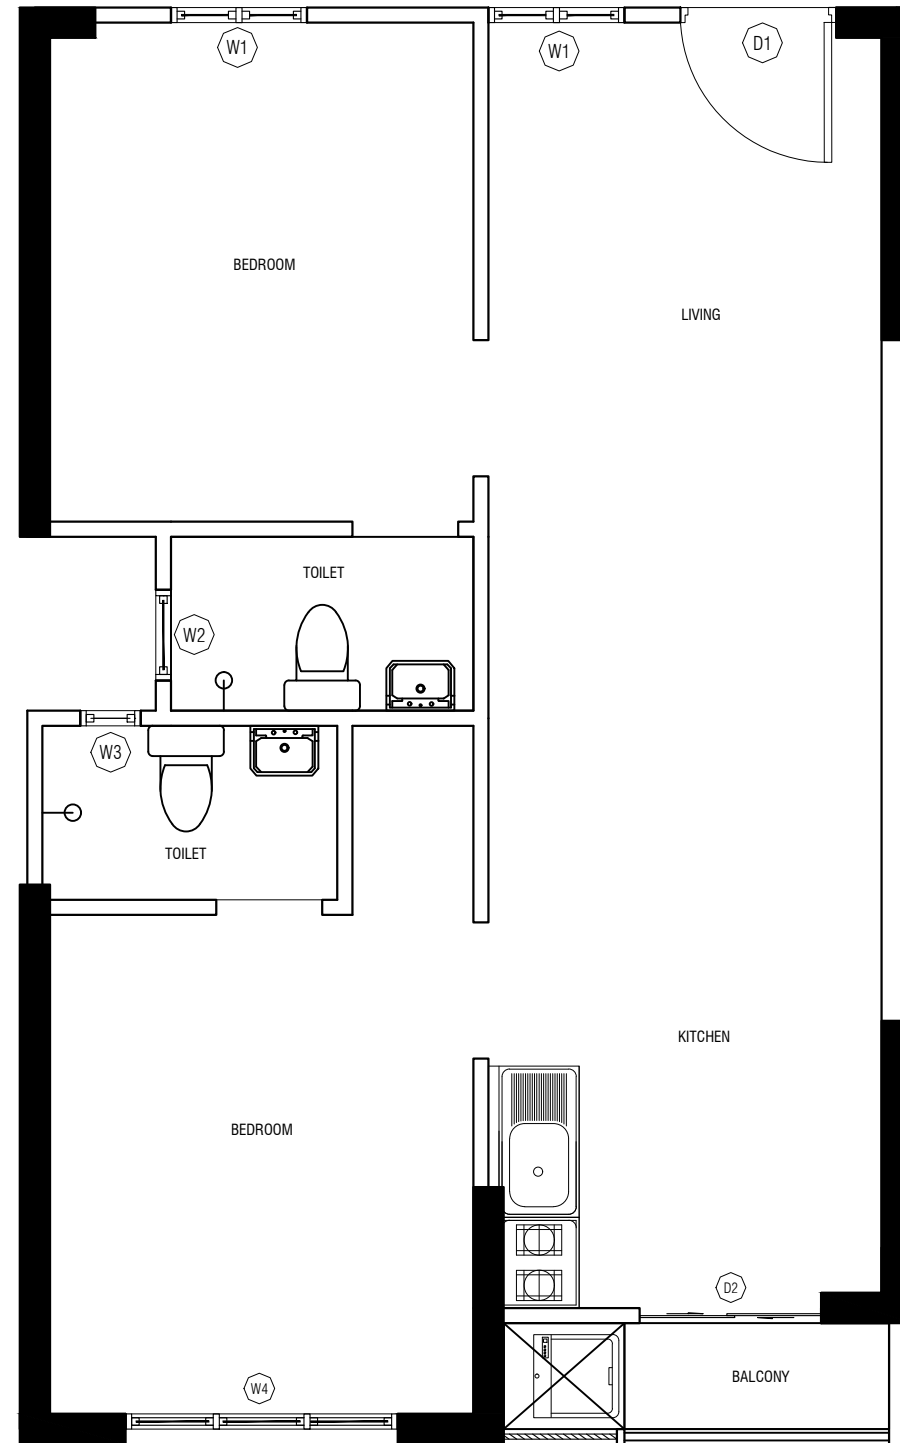

DOORS AND WINDOWS PLAN - (TYPE-1B)

 SCALE 1:50



DESIGNER:

Architectural	Structural
---------------	------------

DRAWN BY:

AMEEN & NAZA
 JUNE 2021

REVISION NAME	DATE

SCALE:	SHEET NO:
-	-

CHECKED BY:


MOHAMED SAIF	NAME
Architectural	Structural
Electrical & Mechanical	Communication

APPROVED BY:

HUSSAIN ZIYATH
 19/04/2020


SHEET CONTENT:

PAGE NO.

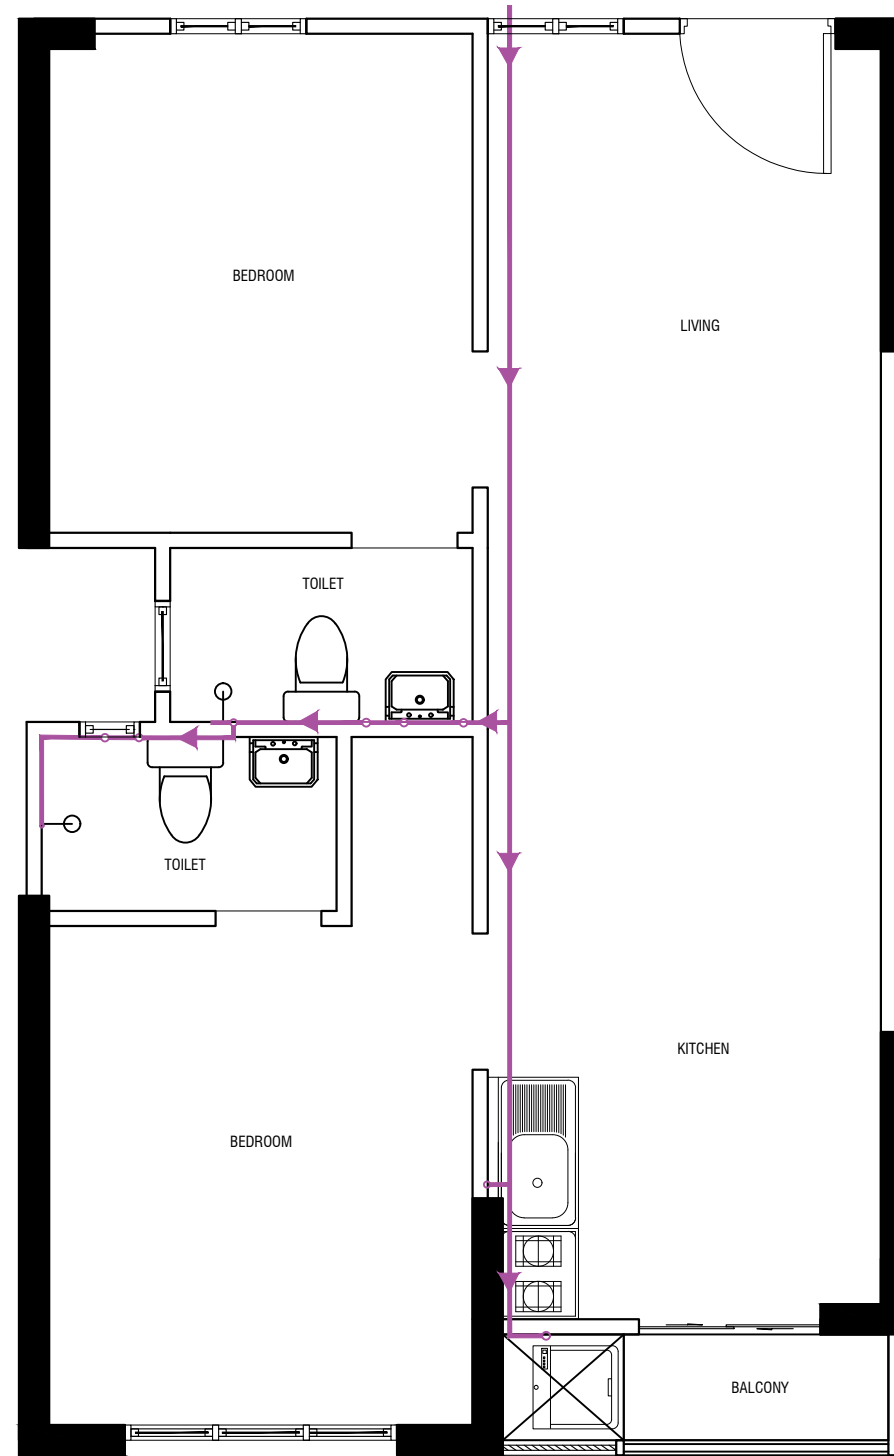

FRESH WATER SUPPLY - (TYPE-1B)

 SCALE 1:50



DESIGNER:	
Architectural	Structural

DRAWN BY:	
AMEEN & NAZA	
JUNE 2021	
REVISION	
NAME	DATE
SCALE:	SHEET NO:

CHECKED BY:	
MOHAMED SAIF	NAME
Architectural	Structural
Electrical & Mechanical	Communication


APPROVED BY:
HUSSAIN ZIYATH
19/04/2020

SHEET CONTENT:

PLAN						
ELEVATION						
Finished Floor Level						
DOOR / WINDOW SYMBOL (No.)	D1	D2	W1	W2	W3	W4
TYPE	WOODEN DOOR	ALUMINIUM SLIDING DOOR	ALUMINIUM WINDOW	ALUMINIUM WINDOW	ALUMINIUM WINDOW	ALUMINIUM WINDOW

DOORS AND WINDOWS SCHEDULE

 SCALE 1:50



DESIGNER:

Architectural	Structural

DRAWN BY:

AMEEN & NAZA	
JUNE 2021	
REVISION	DATE
NAME	DATE
SCALE:	SHEET NO:

CHECKED BY:

MOHAMED SAIF	NAME
Architectural	Structural
Electrical & Mechanical	Communication

APPROVED BY:

HUSSAIN ZIYATH
19/04/2020


SHEET CONTENT:

PAGE NO.

PLAN			
ELEVATION			
Finished Floor Level			
DOOR / WINDOW SYMBOL (No.)	W5	W6	D6
TYPE	ALUMINIUM WINDOW	ALUMINIUM WINDOW	ALUMINIUM AND GLASS

DOORS AND WINDOWS SCHEDULE

 SCALE 1:50



DESIGNER:

Architectural	Structural

DRAWN BY:

AMEEN & NAZA	
JUNE 2021	
REVISION	DATE
NAME	
SCALE:	SHEET NO:

CHECKED BY:

MOHAMED SAIF	NAME
Architectural	Structural
Electrical & Mechanical	Communication

APPROVED BY:

HUSSAIN ZIYATH
19/04/2020

SHEET CONTENT:

PAGE NO.