

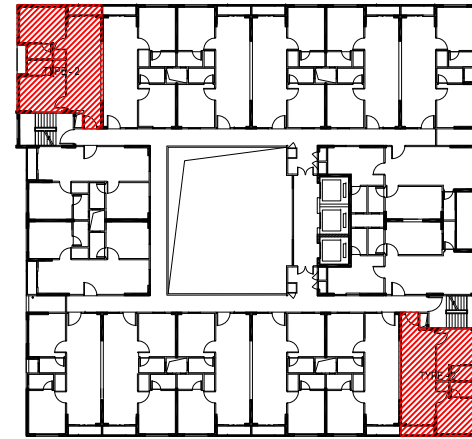



UNIT TYPE - 2

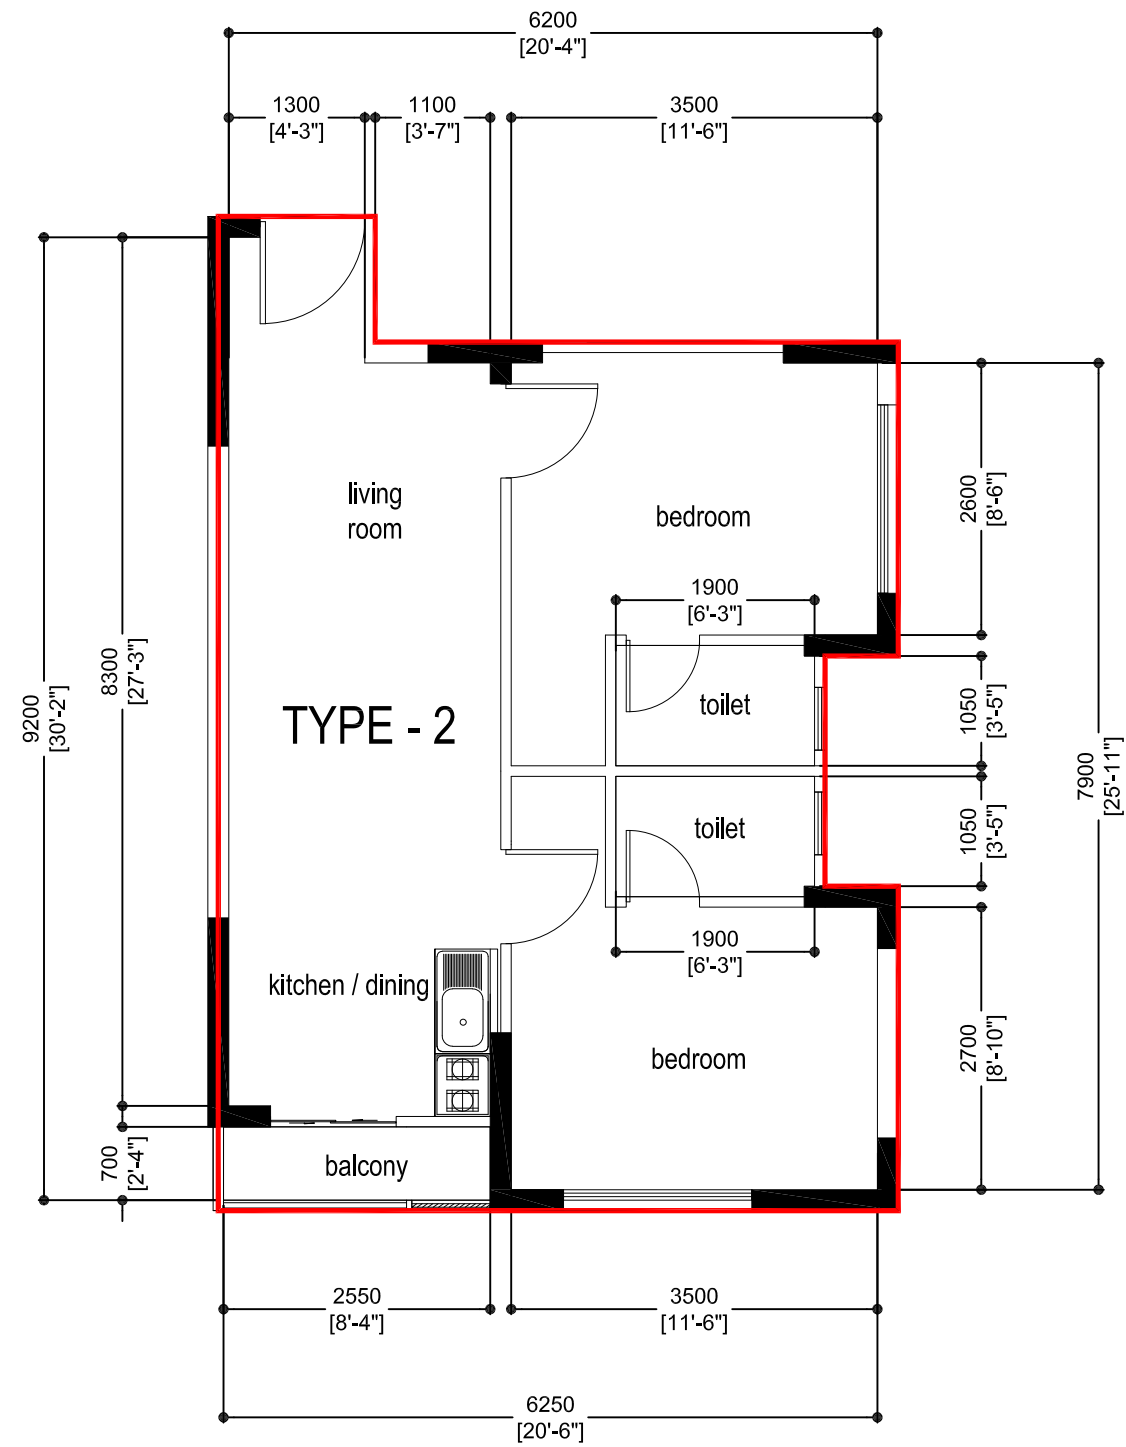

16 UNITS BUILDING

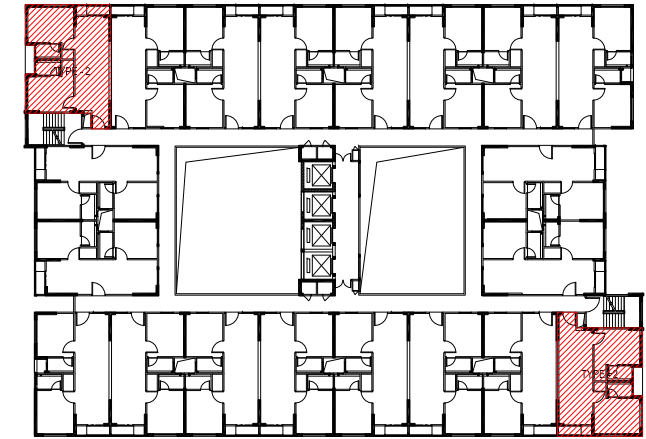

20 UNITS BUILDING

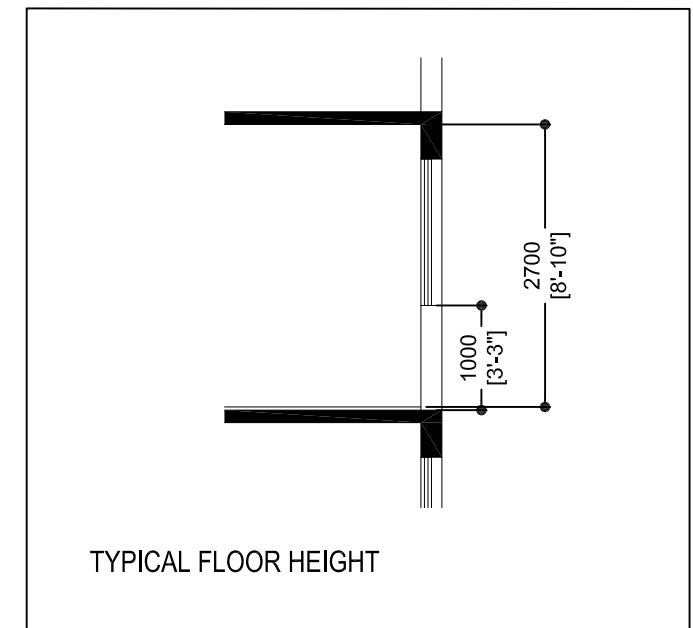

■ SHEAR WALLS


□ MASONRY WALLS

THE MEASUREMENTS MENTIONED ABOVE MIGHT BE SUBJECT TO SLIGHT CHANGES ONCE AN AS-BUILT HAS BEEN TAKEN

DETAIL DRAWING


UNIT TYPE - 2 : 54.21 m² (583.51 ft²)

SCALE: 1:100

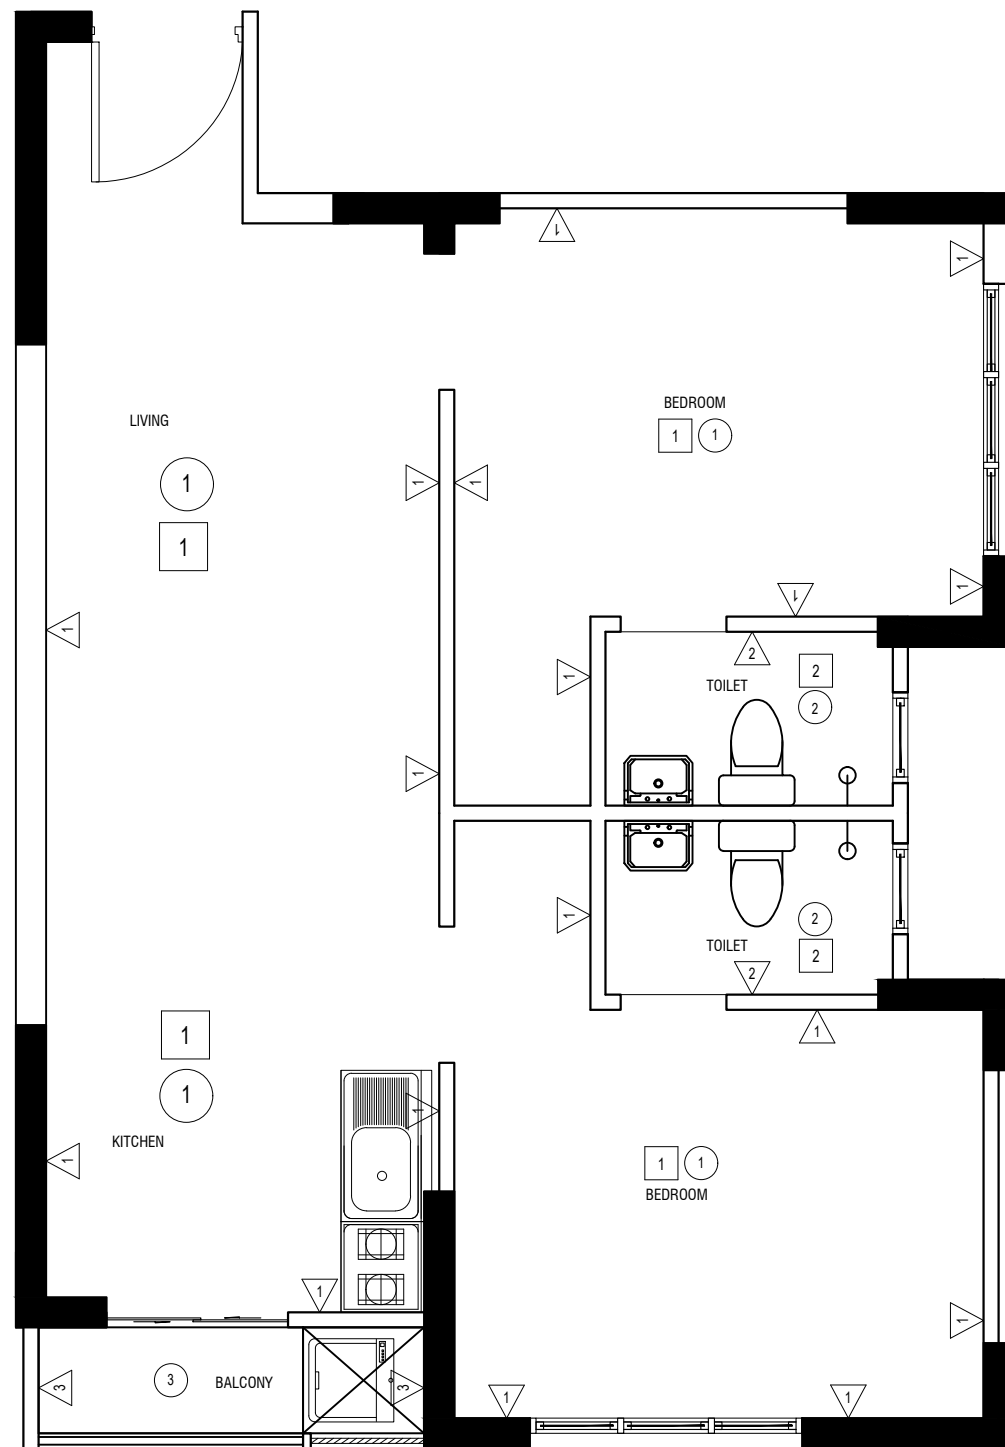

FINISHING SCHEDULE TYPE -2

 
SCALE 1:50



1	FLOOR FINISH
1	CEMENT SCREED
2	TILES


1	CEILING FINISH
1	SLAB SOFFIT WITH WHITE PUTTY
2	GYPSUM BOARD CEILING
3	PAINT FINISH

W	WALL FINISH
1	WHITE PUTTY FINISH
2	WALL TILES UP TO 1200 MM
3	PAINT FINISH

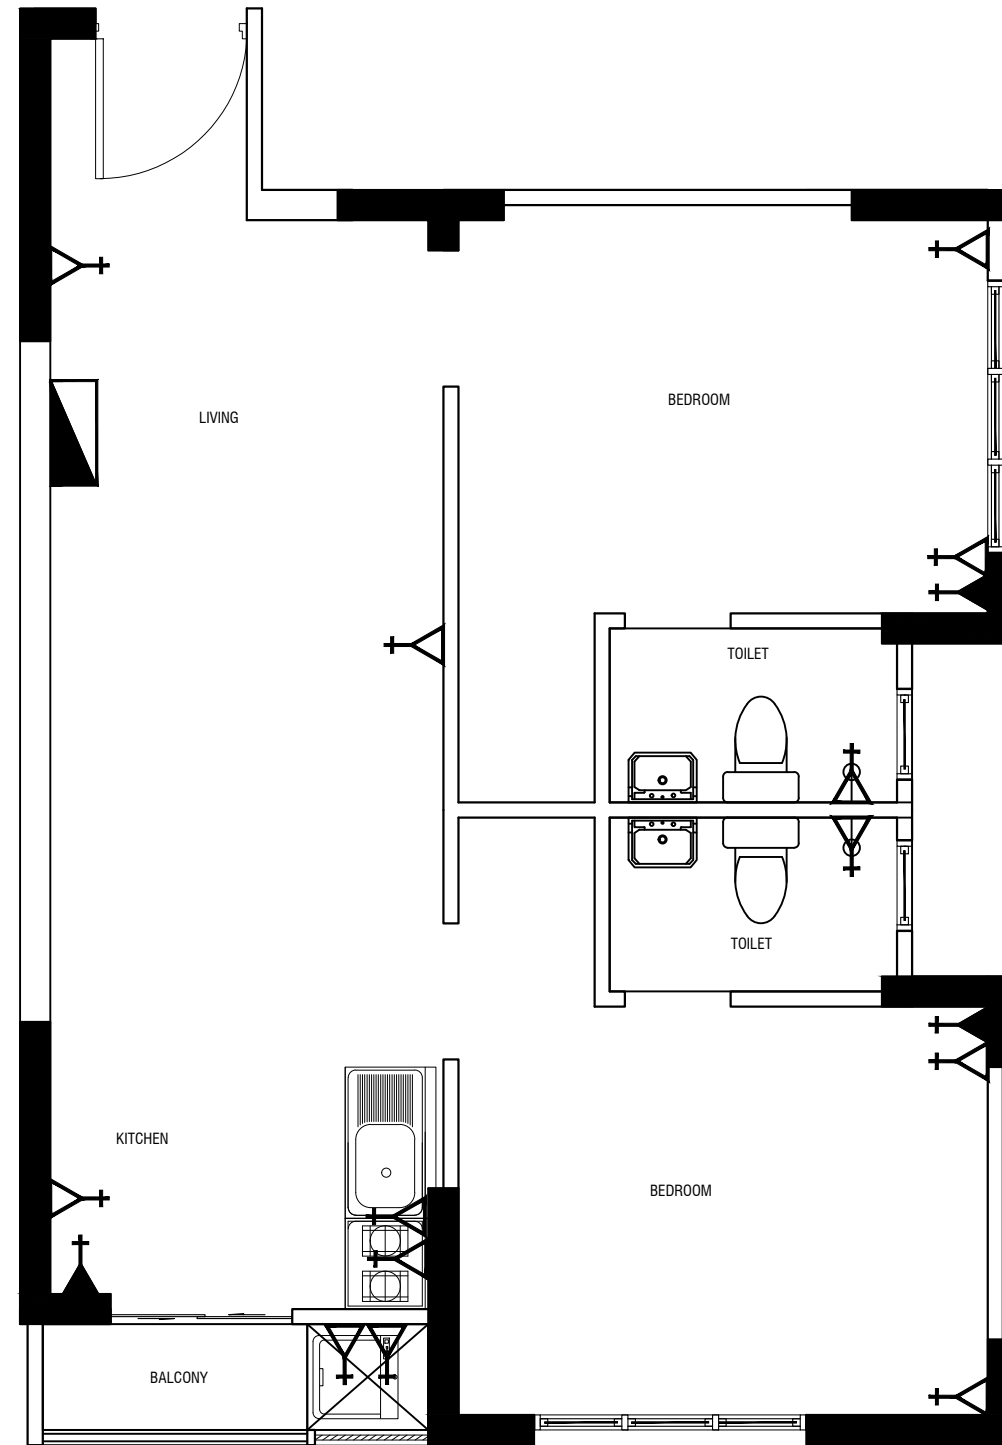


POWER LAYOUT (TYPE -2)

 SCALE 1:50




LEGEND	
SYMBOL	DESCRIPTION
	13 A SOCKET
	15 A SOCKET
	DISTRIBUTION BOX

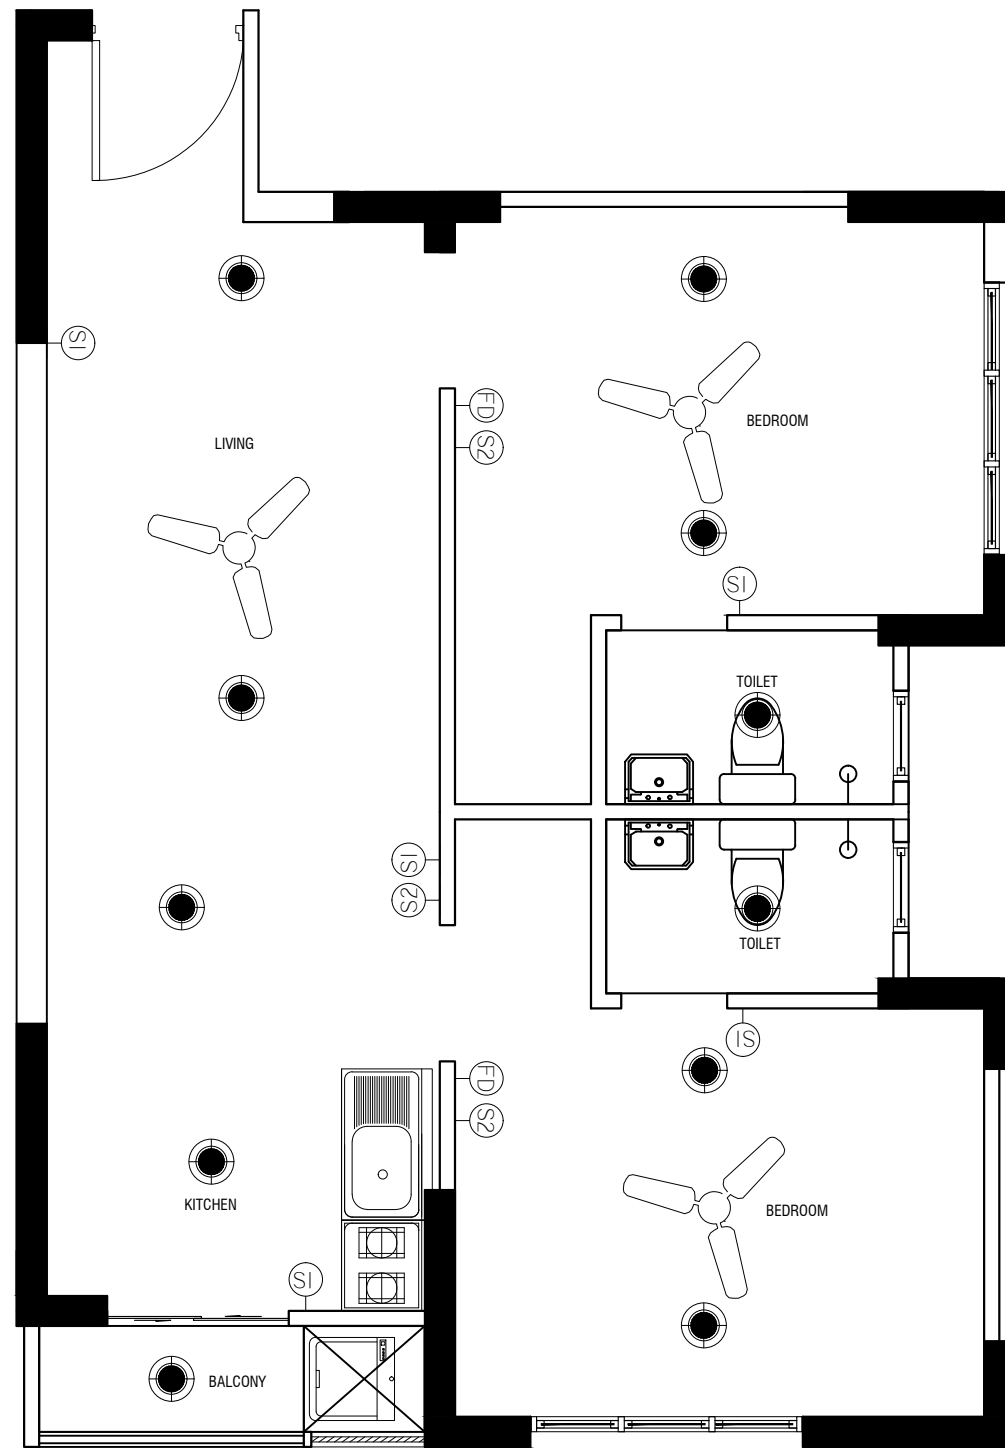


PROVISIONS FOR LIGHTS AND FAN (TYPE -2)

 SCALE 1:50




LEGEND	DESCRIPTION
	PROVISION FOR LIGHT
	PROVISION FOR FAN
	SINGLE GANG SWITCH
	DOUBLE GANG SWITCH
	FAN CONTROL SWITCH

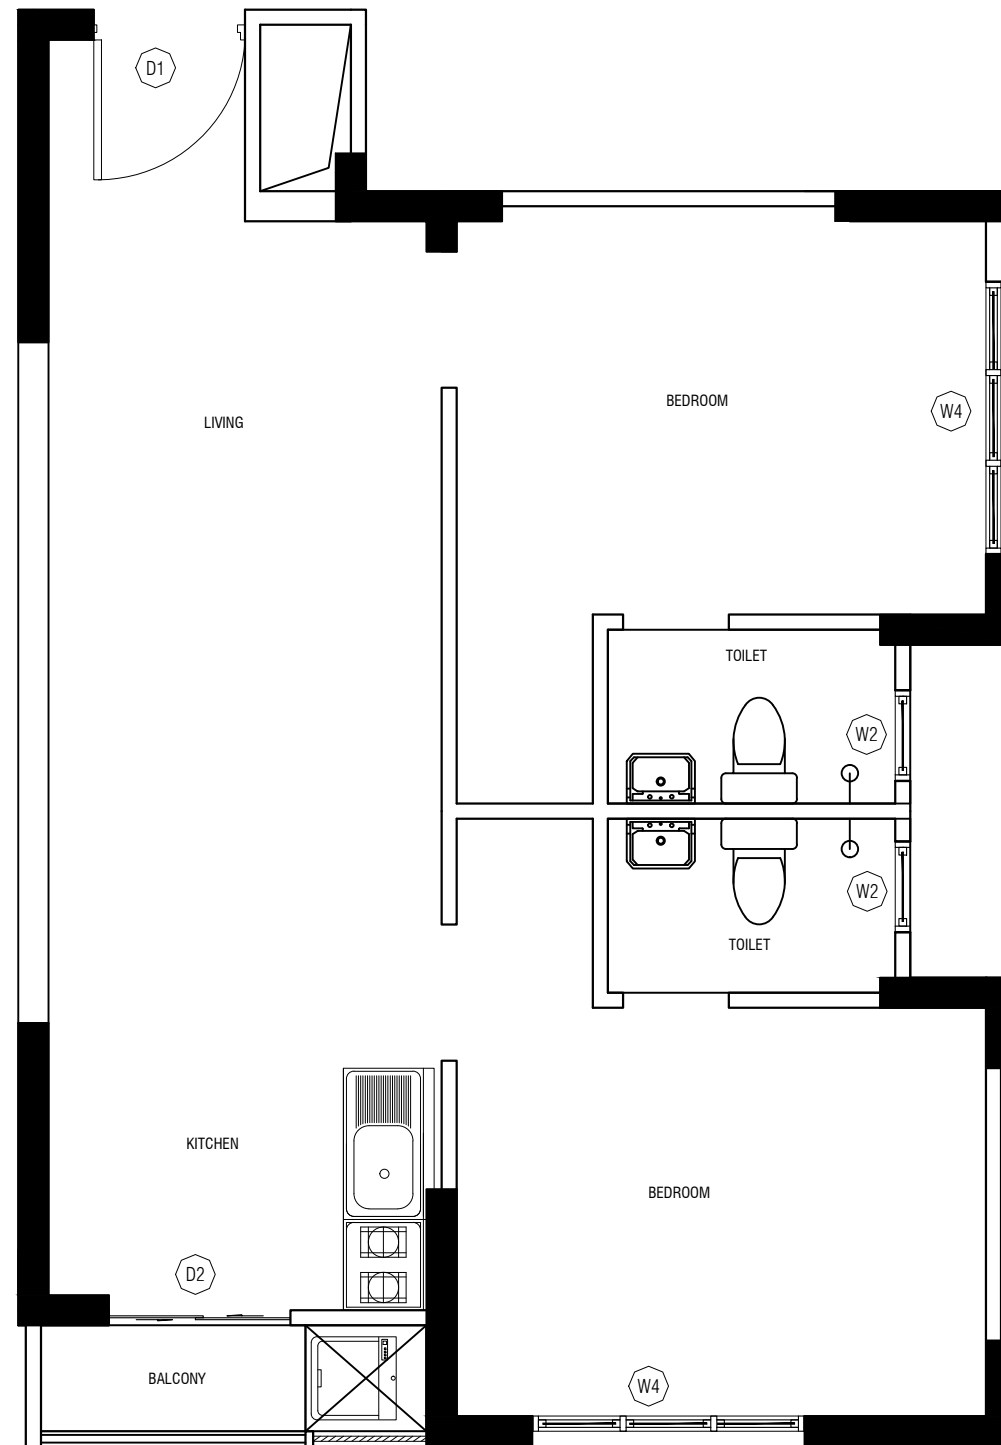

DOORS AND WINDOWS PLAN (TYPE -2)

 SCALE 1:50



DESIGNER:

Architectural	Structural
---------------	------------

DRAWN BY:

AMEEN & NAZA	
JUNE 2021	
REVISION	DATE
NAME	DATE
SCALE:	SHEET NO:

CHECKED BY:


MOHAMED SAIF	NAME
Architectural	Structural
Electrical & Mechanical	Communication

APPROVED BY:

HUSSAIN ZIYATH
19/04/2020


SHEET CONTENT:

PAGE NO.

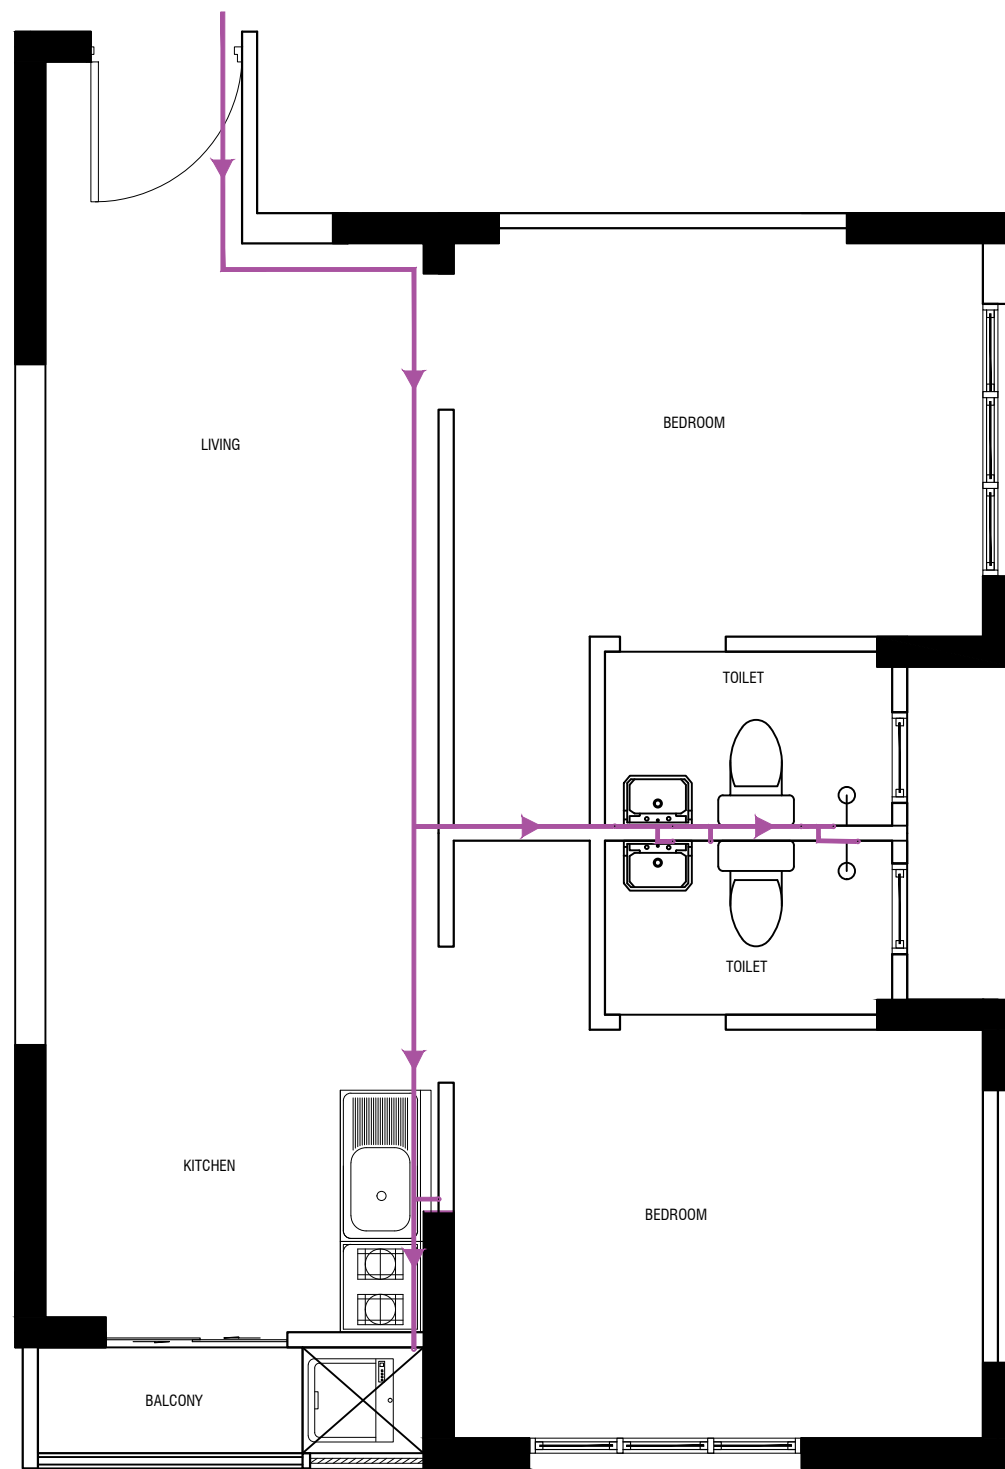

FRESH WATER SUPPLY - (TYPE-2)

 SCALE 1:50



DESIGNER:	
Architectural	Structural

DRAWN BY:	
AMEEN & NAZA	
JUNE 2021	
REVISION	
NAME	DATE
SCALE:	SHEET NO:

CHECKED BY:	
MOHAMED SAIF	NAME
Architectural	Structural
Electrical & Mechanical	Communication


APPROVED BY:
HUSSAIN ZIYATH
19/04/2020

SHEET CONTENT:

PLAN						
ELEVATION						
Finished Floor Level						
DOOR / WINDOW SYMBOL (No.)	D1	D2	W1	W2	W3	W4
TYPE	WOODEN DOOR	ALUMINIUM SLIDING DOOR	ALUMINIUM WINDOW	ALUMINIUM WINDOW	ALUMINIUM WINDOW	ALUMINIUM WINDOW

DOORS AND WINDOWS SCHEDULE

 SCALE 1:50



PLANNING AND DEVELOPMENT DEPARTMENT
THIRD FLOOR, HDC BUILDING HULHUMALE'
REPUBLIC OF MALDIVES
TEL. +(960)3353535, FAX +(960)3358892
EMAIL : planning@hdc.com.mv

7000 HOUSING PROJECT HULHUMALE'

The drawings, concept and design contained are the properties of HDC. Use of any kind or copy of whole or part of this drawing, concept or design or use on other projects or sites other than that specified on this drawing is strictly prohibited.

DESIGNER:

Architectural	Structural
---------------	------------

DRAWN BY:

AMEEN & NAZA	
JUNE 2021	
REVISION	DATE
NAME	DATE
SCALE:	SHEET NO:
-	-

CHECKED BY:

MOHAMED SAIF	NAME
Architectural	Structural
Electrical & Mechanical	Communication

APPROVED BY:

HUSSAIN ZIYATH
19/04/2020

SHEET CONTENT:

PAGE NO.

06

PLAN			
ELEVATION			
Finished Floor Level			
DOOR / WINDOW SYMBOL (No.)	W5	W6	D6
TYPE	ALUMINIUM WINDOW	ALUMINIUM WINDOW	ALUMINIUM AND GLASS

DOORS AND WINDOWS SCHEDULE

SCALE 1:50

