

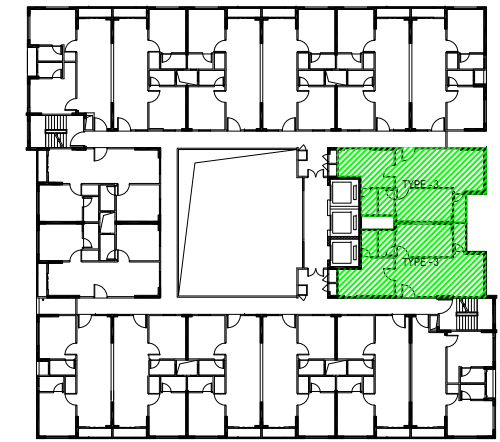



 
# UNIT TYPE - 3

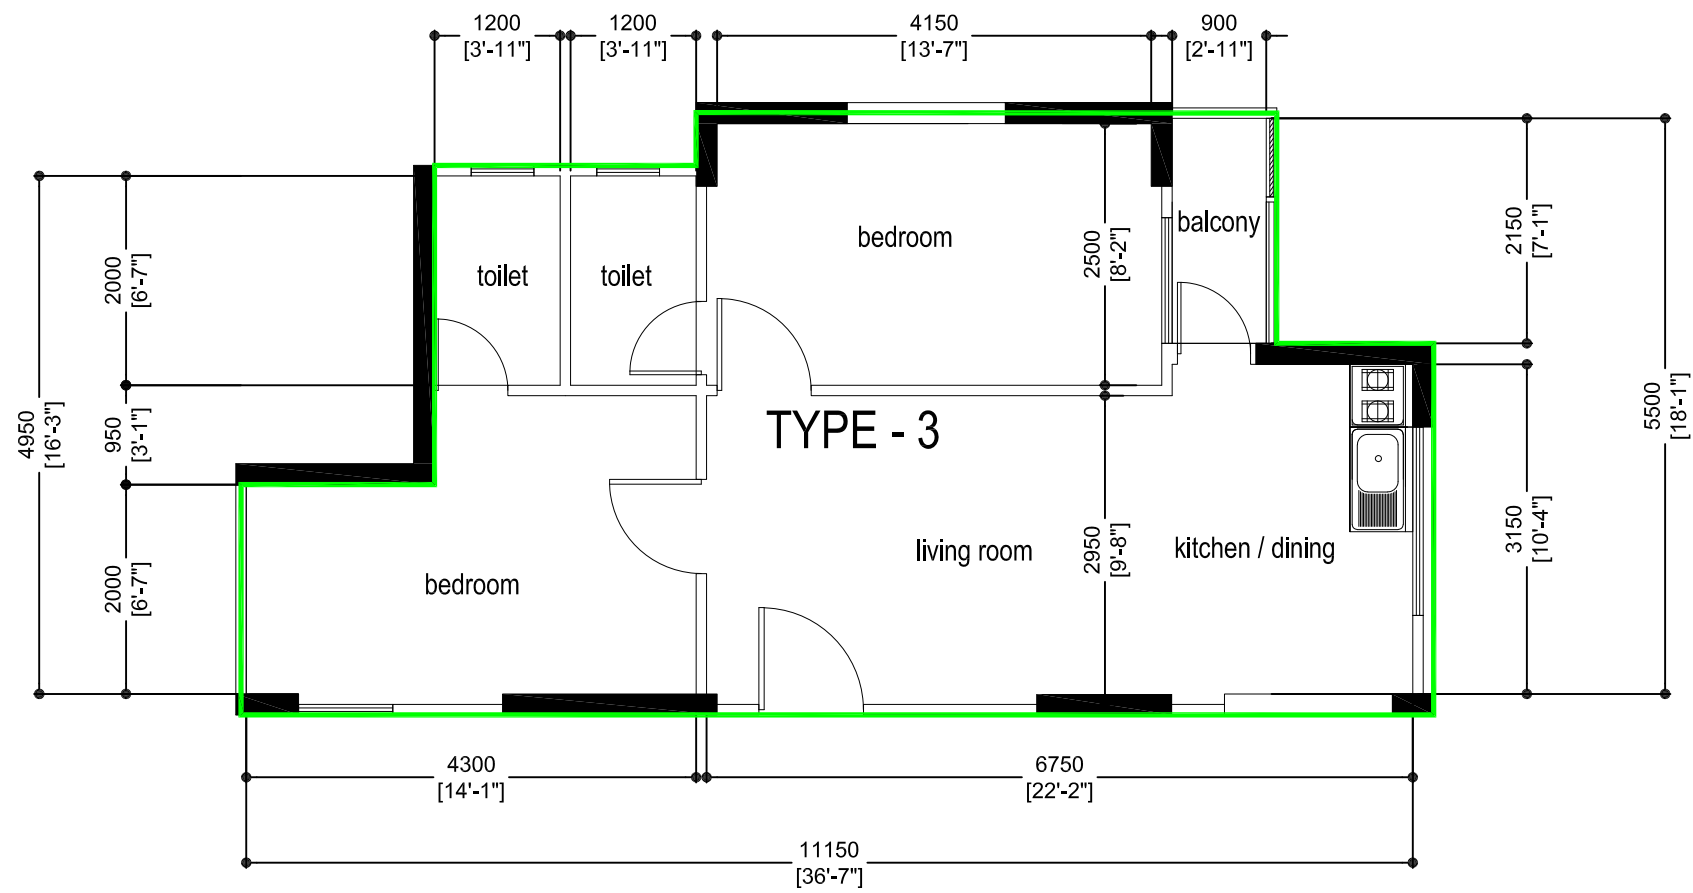

16 UNITS BUILDING

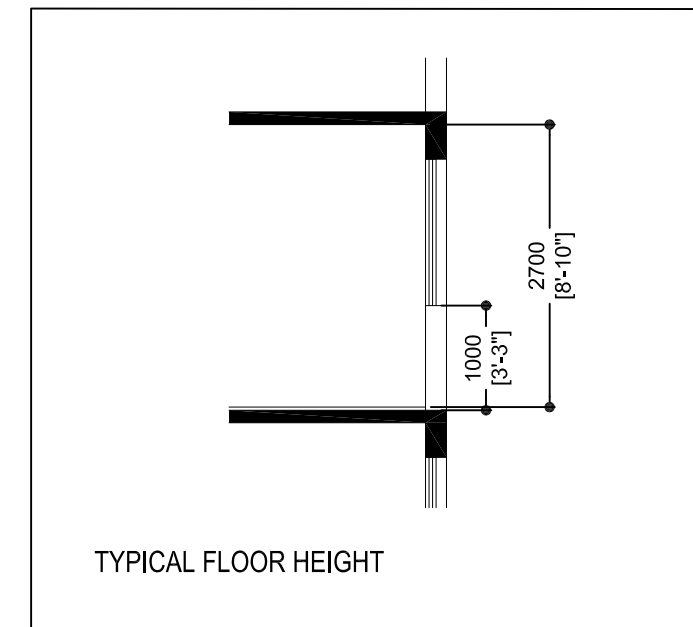

TYPICAL FLOOR HEIGHT


-  SHEAR WALLS
-  MASONRY WALLS

DETAIL DRAWING

UNIT TYPE - 3 : 54.45 m<sup>2</sup> (586.09 ft<sup>2</sup>)


SCALE: 1:100

THE MEASUREMENTS MENTIONED ABOVE MIGHT BE SUBJECT TO SLIGHT CHANGES ONCE AN AS-BUILT HAS BEEN TAKEN

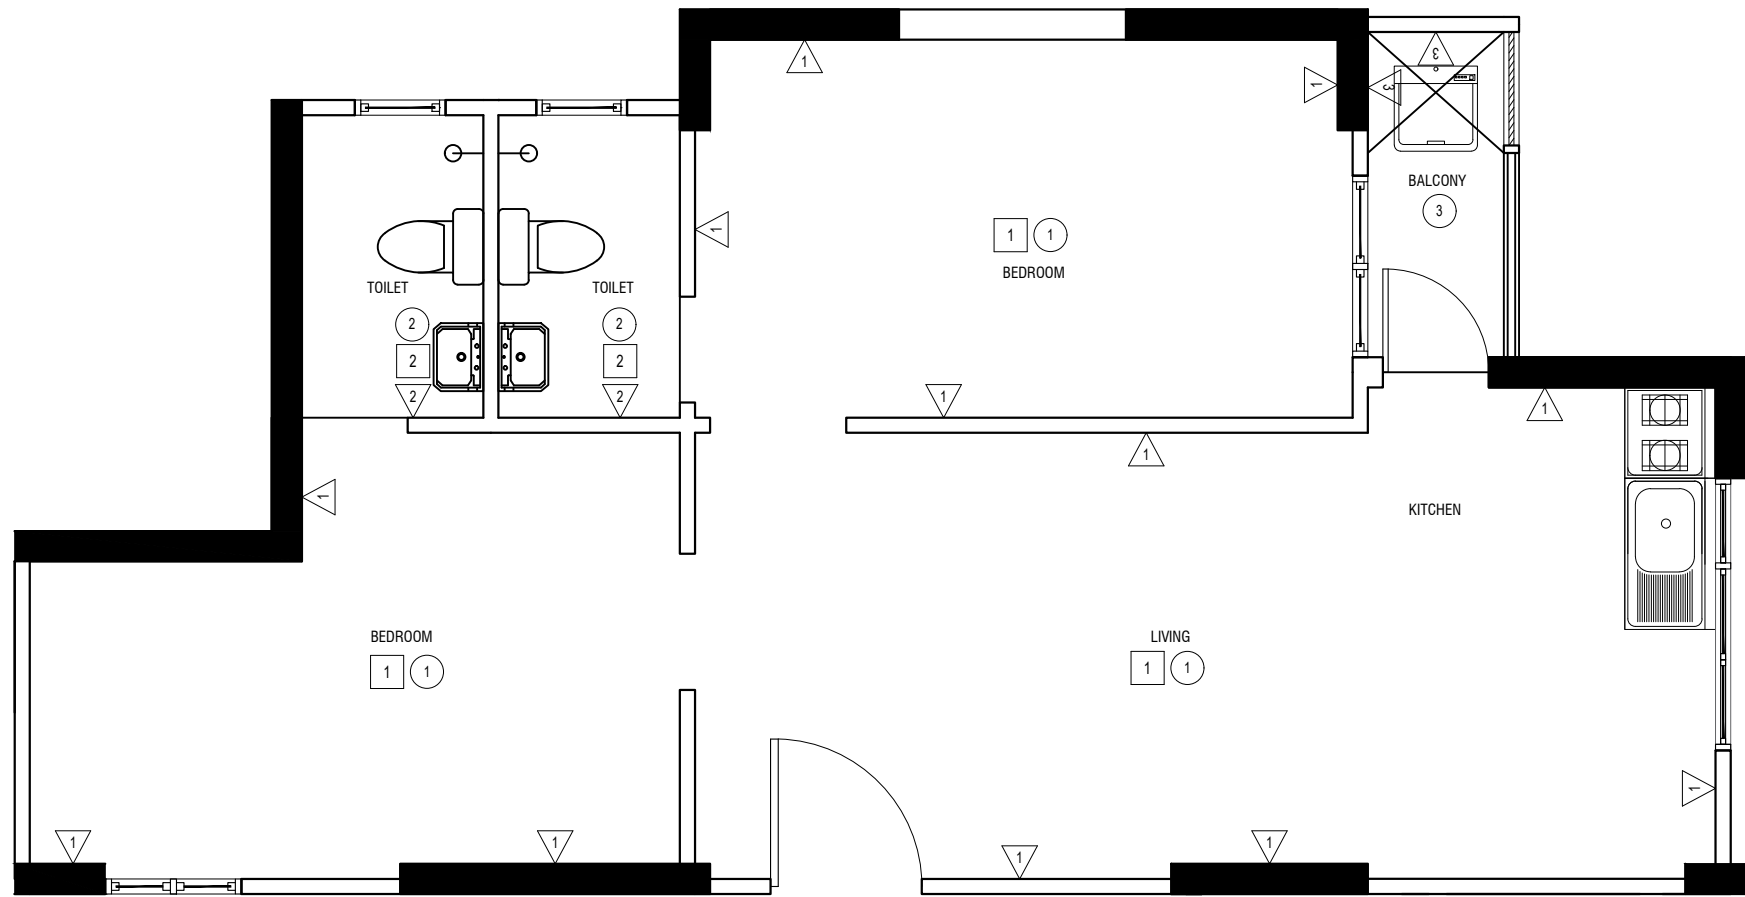

**FINISHING SCHEDULE TYPE -3**

 SCALE 1:50



1	<b>FLOOR FINISH</b>
1	CEMENT SCREED
2	TILES
1	<b>CEILING FINISH</b>
1	SLAB SOFFIT WITH WHITE PUTTY
2	GYPSUM BOARD CEILING
3	PAINT FINISH
W	<b>WALL FINISH</b>
1	WHITE PUTTY FINISH
2	WALL TILES UP TO 1200 MM
3	PAINT FINISH

DESIGNER:

Architectural	Structural

DRAWN BY:

**AMEEN & NAZA**  
JUNE 2021

REVISION NAME	DATE

SCALE: \_\_\_\_\_ SHEET NO: \_\_\_\_\_

CHECKED BY:

<b>MOHAMED SAIF</b>	<b>NAME</b>
Architectural	Structural
Electrical & Mechanical	Communication


APPROVED BY:

**HUSSAIN ZIYATH**  
19/04/2020

SHEET CONTENT:


**29**

PAGE NO.

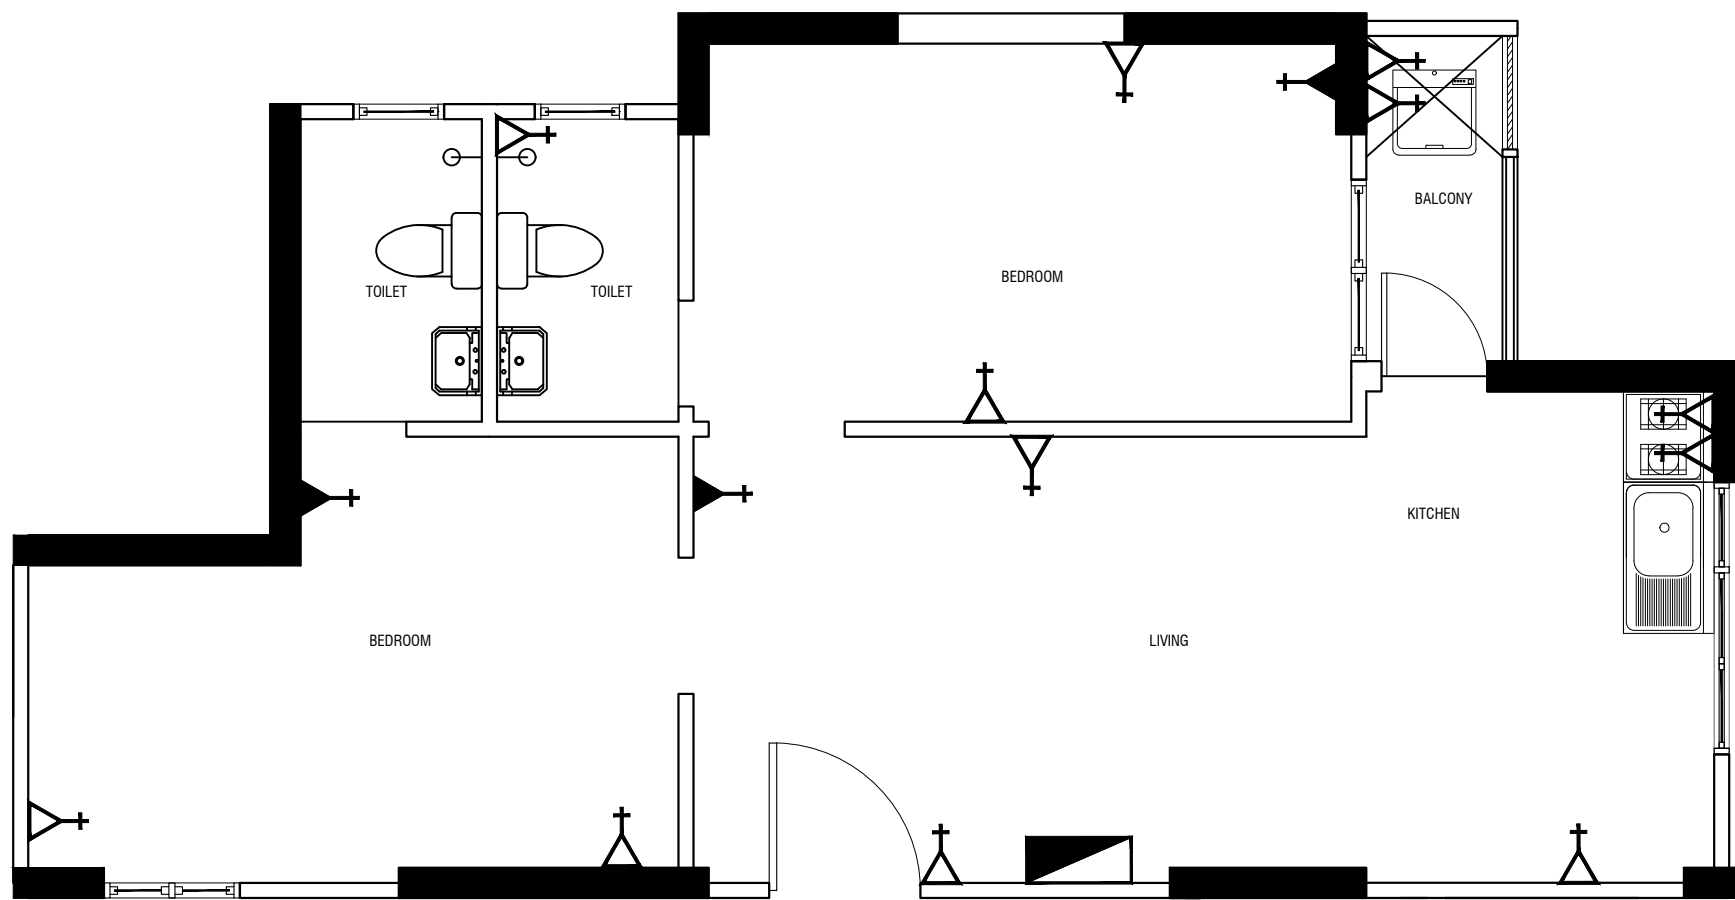


**POWER LAYOUT (TYPE -3)**

 SCALE 1:50




LEGEND	DESCRIPTION
	13 A SOCKET
	15 A SOCKET
	DISTRIBUTION BOX

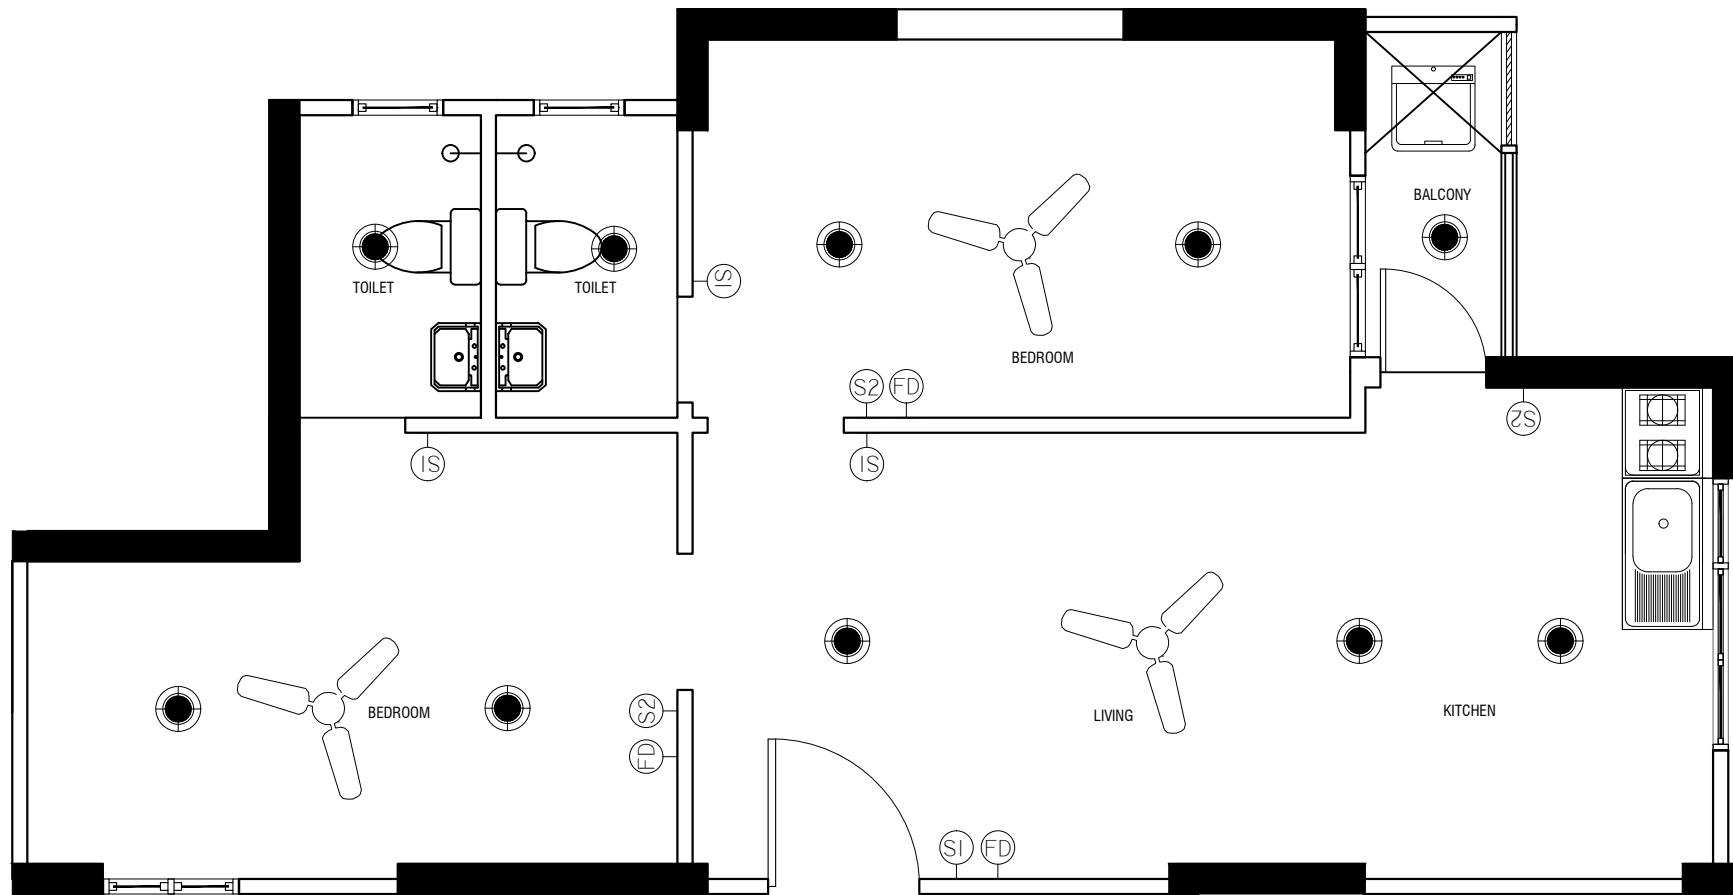


**PROVISIONS FOR LIGHTS AND FAN (TYPE -3)**

 
SCALE 1:50



LEGEND	DESCRIPTION
	PROVISION FOR LIGHT
	PROVISION FOR FAN
	SINGLE GANG SWITCH
	DOUBLE GANG SWITCH
	FAN CONTROL SWITCH

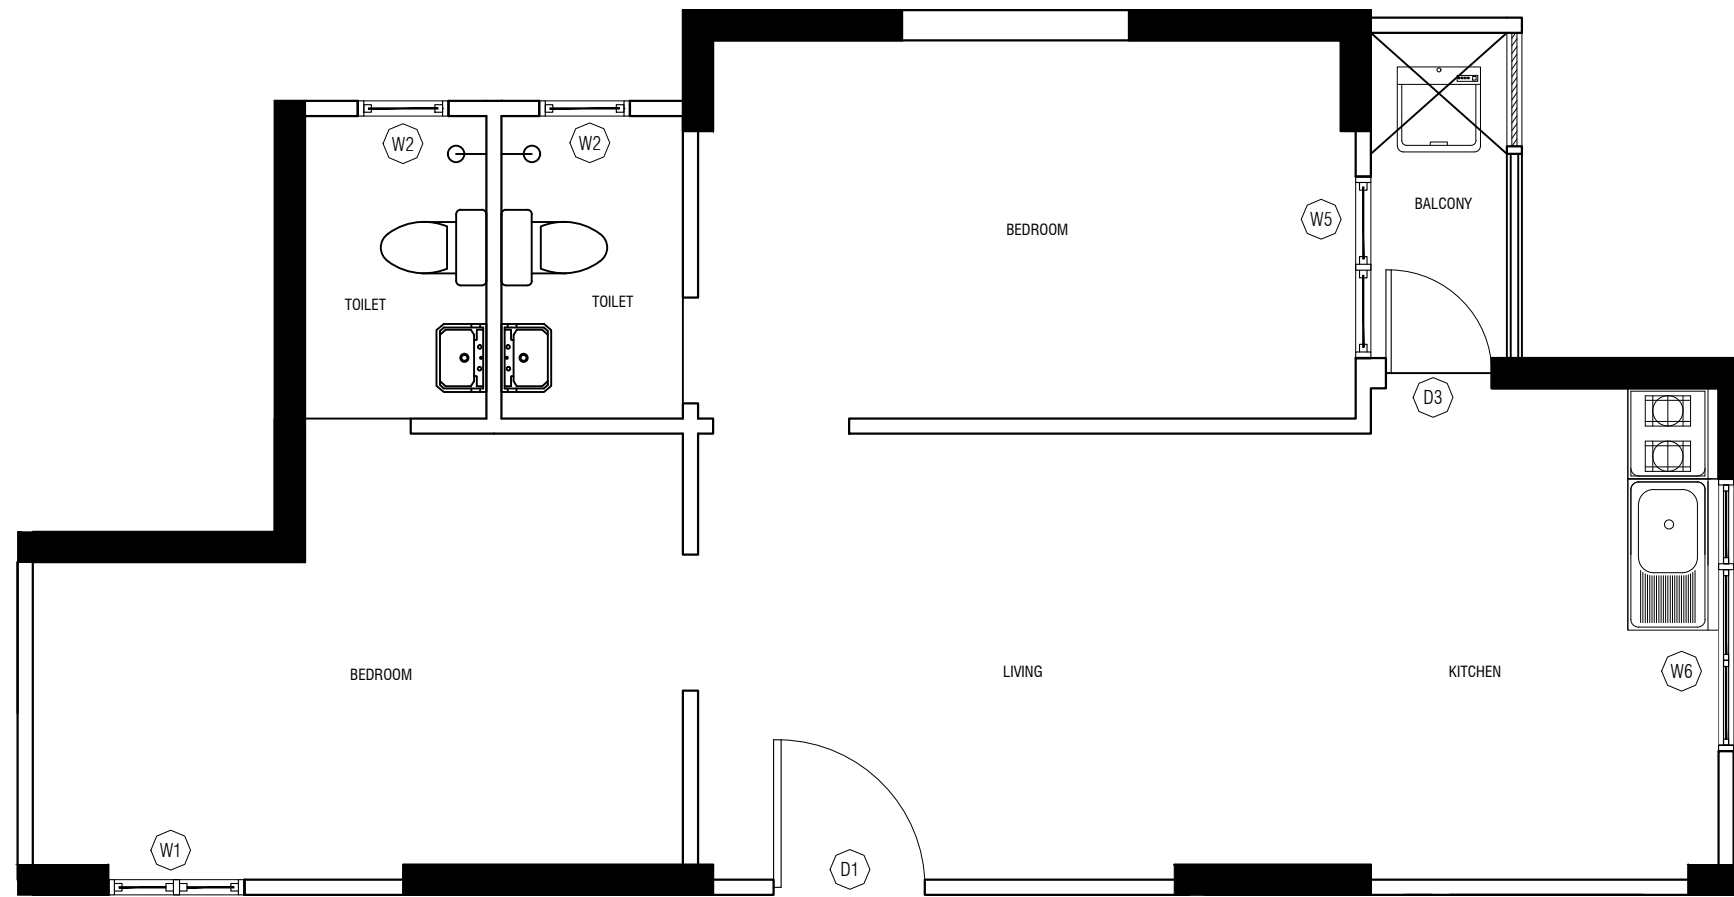

 DOORS AND WINDOWS PLAN (TYPE -3)  
SCALE 1:50



DESIGNER:

Architectural	Structural
---------------	------------

DRAWN BY:

AMEEN & NAZA	
JUNE 2021	
REVISION	DATE
NAME	
SCALE:	SHEET NO:
-	-

CHECKED BY:

MOHAMED SAIF	NAME
Architectural	Structural
Electrical & Mechanical	Communication


APPROVED BY:

HUSSAIN ZIYATH
19/04/2020

SHEET CONTENT:


----

PAGE NO.

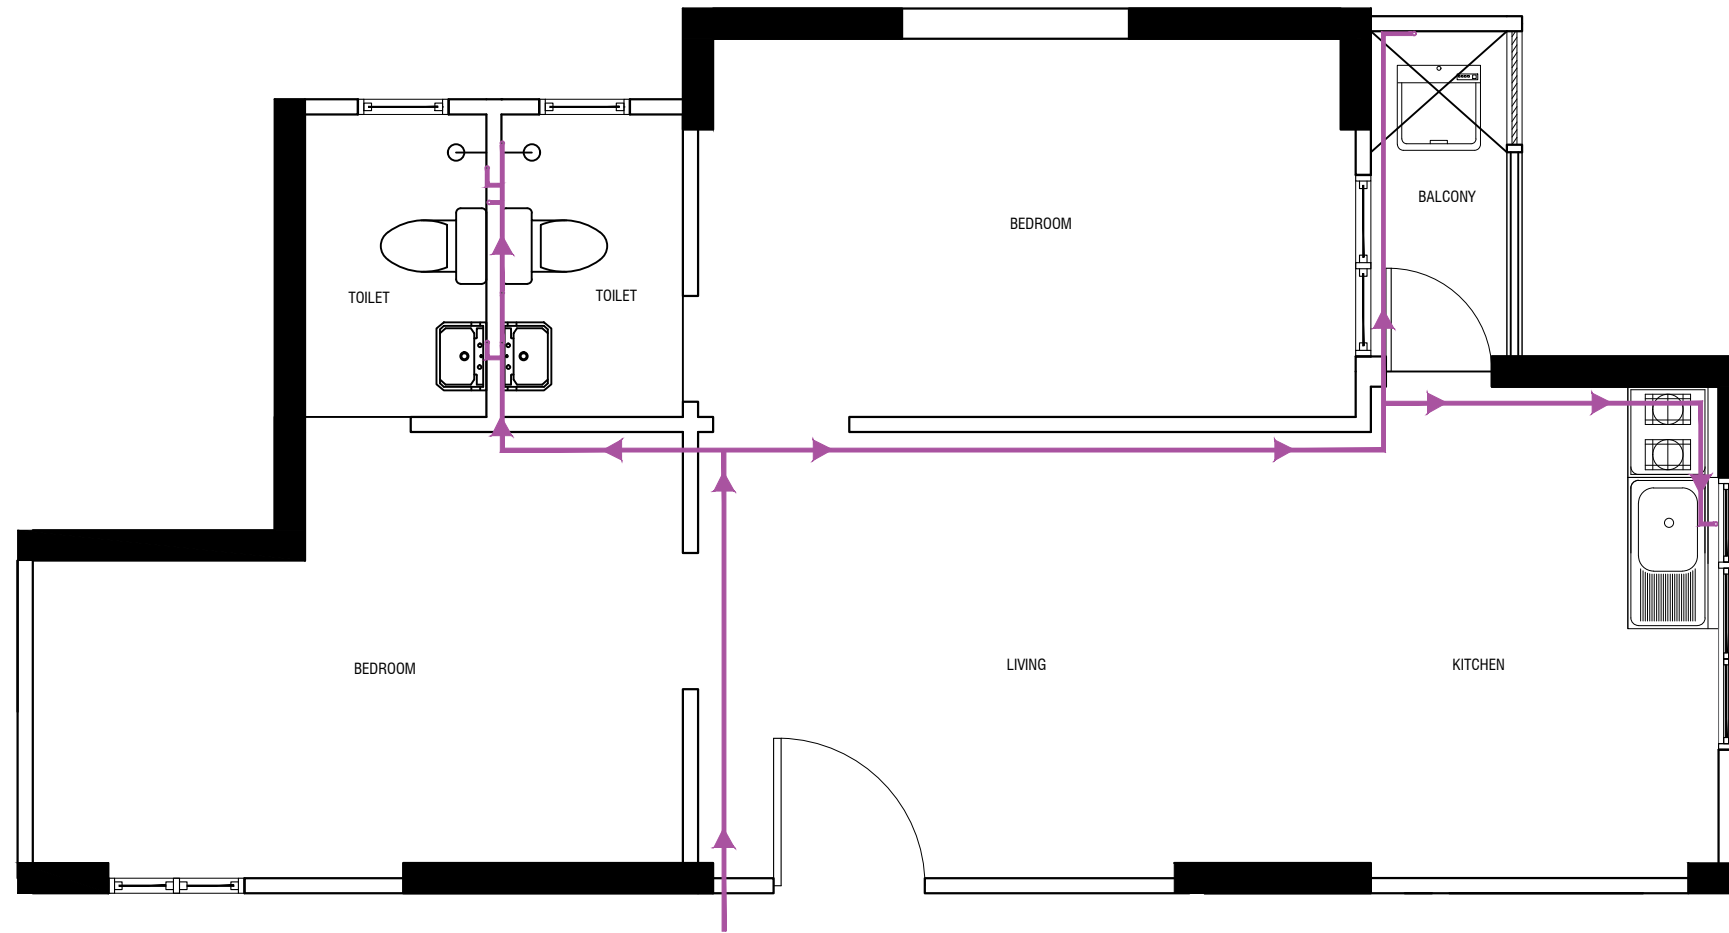

FRESH WATER SUPPLY - (TYPE-3)

 SCALE 1:50



DESIGNER:

Architectural	Structural
---------------	------------

DRAWN BY:

AMEEN & NAZA  
JUNE 2021

REVISION

NAME	DATE

SCALE:

SHEET NO:

CHECKED BY:

MOHAMED SAIF  
Architectural

NAME  
Structural

Electrical & Mechanical

Communication

APPROVED BY:

HUSSAIN ZIYATH  
19/04/2020

SHEET CONTENT:


----

PAGE NO.

PLAN						
ELEVATION						
Finished Floor Level						
DOOR / WINDOW SYMBOL (No.)	D1	D2	W1	W2	W3	W4
TYPE	WOODEN DOOR	ALUMINIUM SLIDING DOOR	ALUMINIUM WINDOW	ALUMINIUM WINDOW	ALUMINIUM WINDOW	ALUMINIUM WINDOW

## DOORS AND WINDOWS SCHEDULE

 SCALE 1:50



DESIGNER:

Architectural	Structural

DRAWN BY:

AMEEN & NAZA	
JUNE 2021	
REVISION	DATE
NAME	
SCALE:	SHEET NO:

CHECKED BY:

MOHAMED SAIF	NAME
Architectural	Structural
Electrical & Mechanical	Communication

APPROVED BY:

HUSSAIN ZIYATH
19/04/2020

SHEET CONTENT:


----

PAGE NO.

PLAN			
ELEVATION			
Finished Floor Level			
DOOR / WINDOW SYMBOL (No.)	W5	W6	D6
TYPE	ALUMINIUM WINDOW	ALUMINIUM WINDOW	ALUMINIUM AND GLASS

## DOORS AND WINDOWS SCHEDULE

 SCALE 1:50



DESIGNER:

Architectural	Structural

DRAWN BY:

AMEEN & NAZA	
JUNE 2021	
REVISION	DATE
NAME	
SCALE:	SHEET NO:

CHECKED BY:

MOHAMED SAIF	NAME
Architectural	Structural
Electrical & Mechanical	Communication

APPROVED BY:

HUSSAIN ZIYATH
19/04/2020

SHEET CONTENT:

----

PAGE NO.